




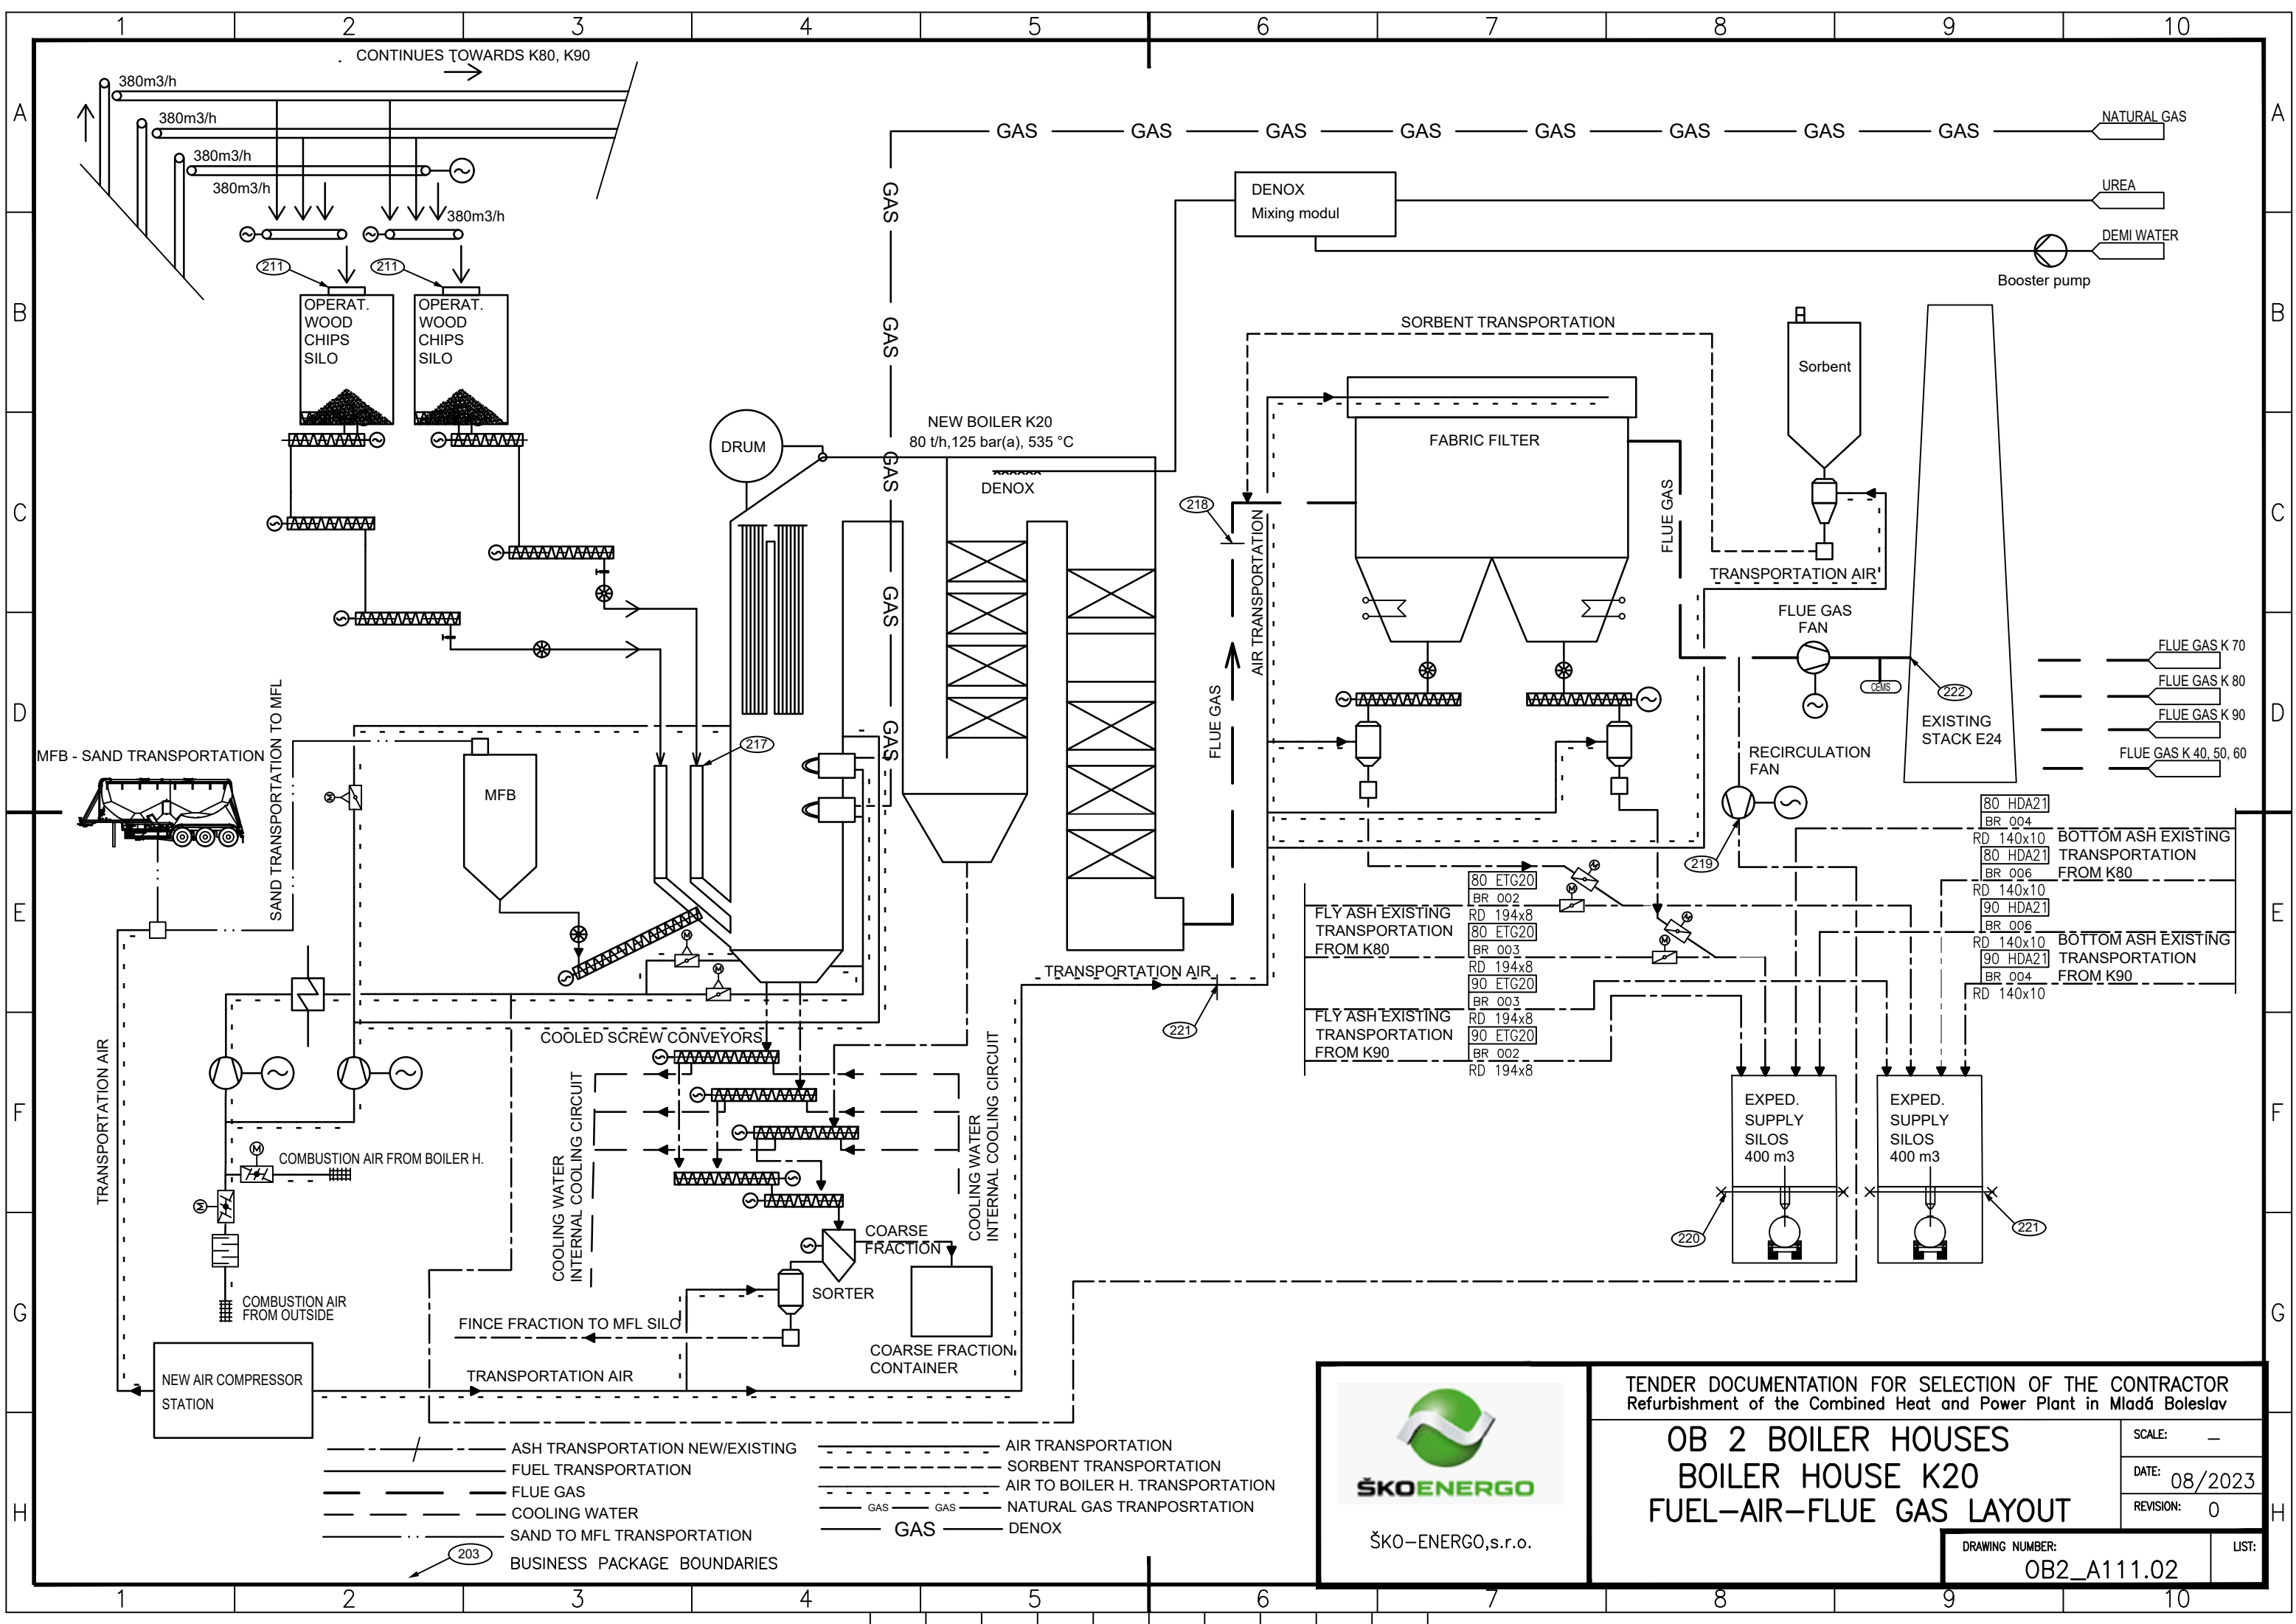

ŠKO-ENERGO, s.r.o.

TENDER DOCUMENTATION FOR SELECTION OF THE CONTRACTOR
Refurbishment of the Combined Heat and Power Plant in Mladá Boleslav

OB 2 BOILER HOUSES
BOILER HOUSE K20
FUEL-AIR-FLUE GAS LAYOUT

SCALE:	—
DATE:	08/2023
REVISION:	0

DRAWING NUMBER:	OB2_A111.02
LIST:	