


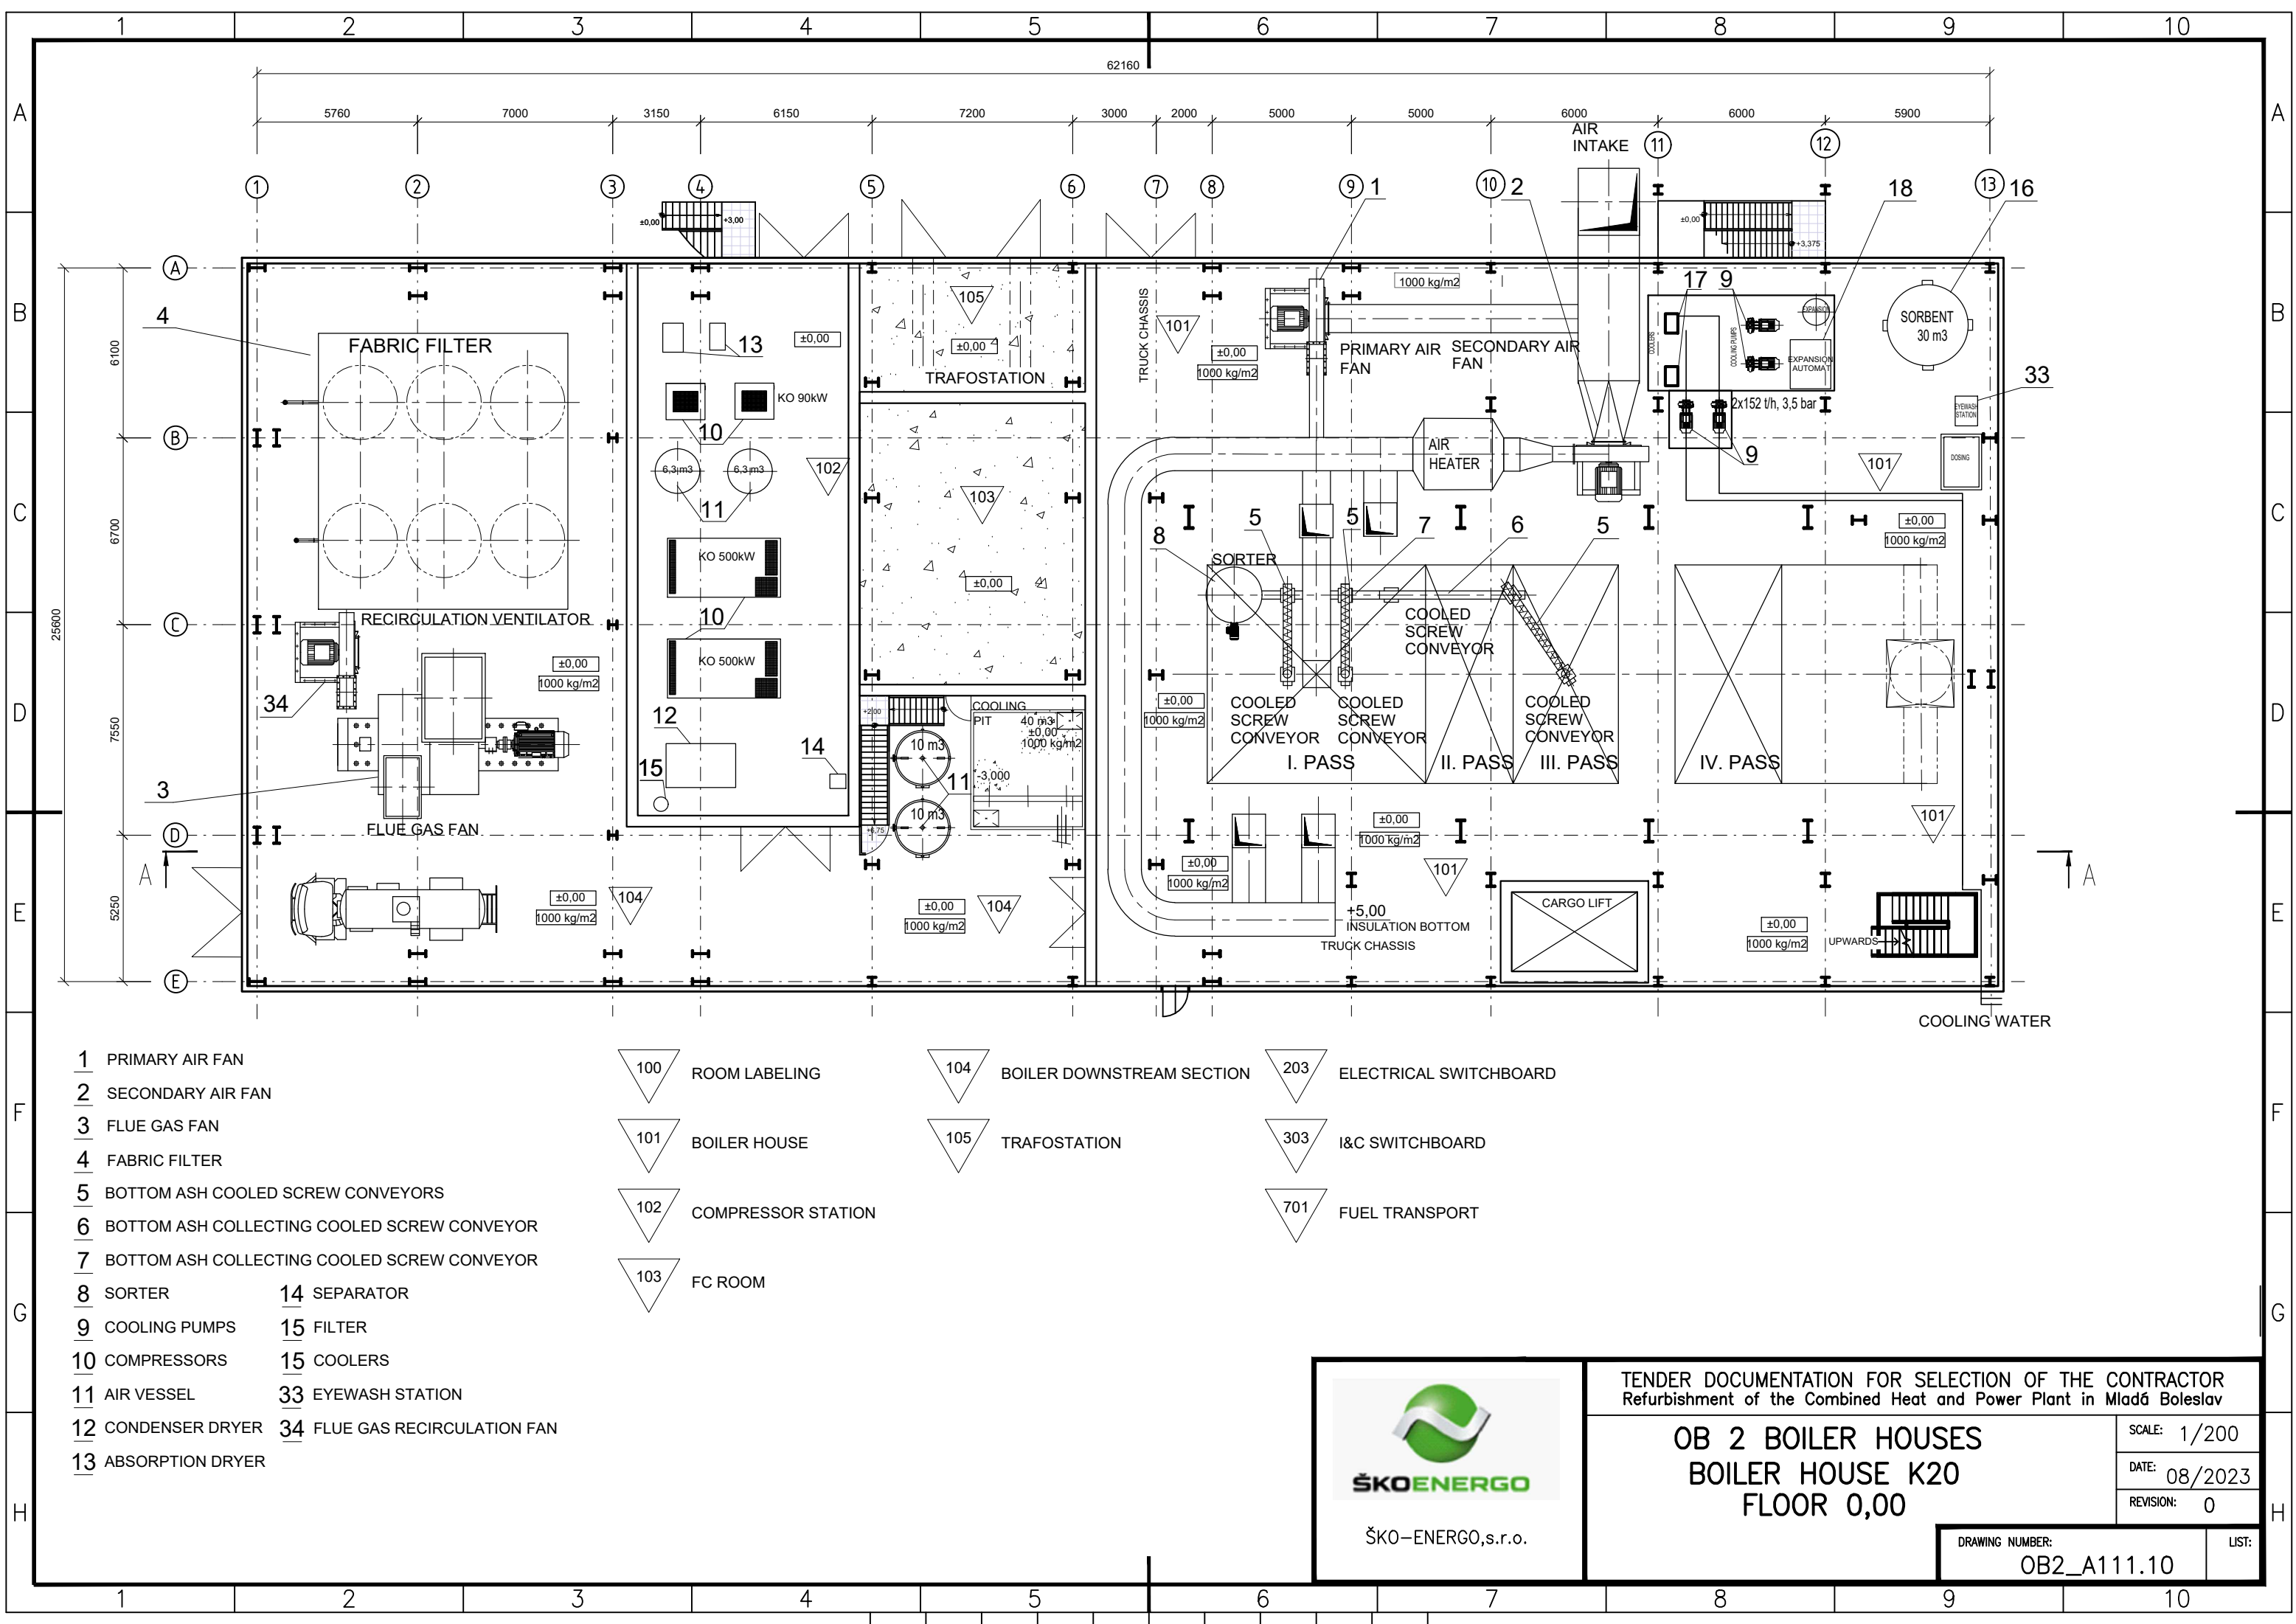

- 1 PRIMARY AIR FAN
- 2 SECONDARY AIR FAN
- 3 FLUE GAS FAN
- 4 FABRIC FILTER
- 5 BOTTOM ASH COOLED SCREW CONVEYORS
- 6 BOTTOM ASH COLLECTING COOLED SCREW CONVEYOR
- 7 BOTTOM ASH COLLECTING COOLED SCREW CONVEYOR
- 8 SORTER
- 9 COOLING PUMPS
- 10 COMPRESSORS
- 11 AIR VESSEL
- 12 CONDENSER DRYER
- 13 ABSORPTION DRYER
- 14 SEPARATOR
- 15 FILTER
- 15 COOLERS
- 33 EYEWASH STATION
- 34 FLUE GAS RECIRCULATION FAN

- 100 ROOM LABELING
- 101 BOILER HOUSE
- 102 COMPRESSOR STATION
- 103 FC ROOM
- 104 BOILER DOWNSTREAM SECTION
- 105 TRAFOSTATION
- 203 ELECTRICAL SWITCHBOARD
- 303 I&C SWITCHBOARD
- 701 FUEL TRANSPORT



ŠKO-ENERGO,s.r.o.

TENDER DOCUMENTATION FOR SELECTION OF THE CONTRACTOR
Refurbishment of the Combined Heat and Power Plant in Mladá Boleslav

OB 2 BOILER HOUSES
BOILER HOUSE K20
FLOOR 0,00

SCALE: 1/200	LIST:
DATE: 08/2023	
REVISION: 0	

DRAWING NUMBER: OB2_A111.10
