


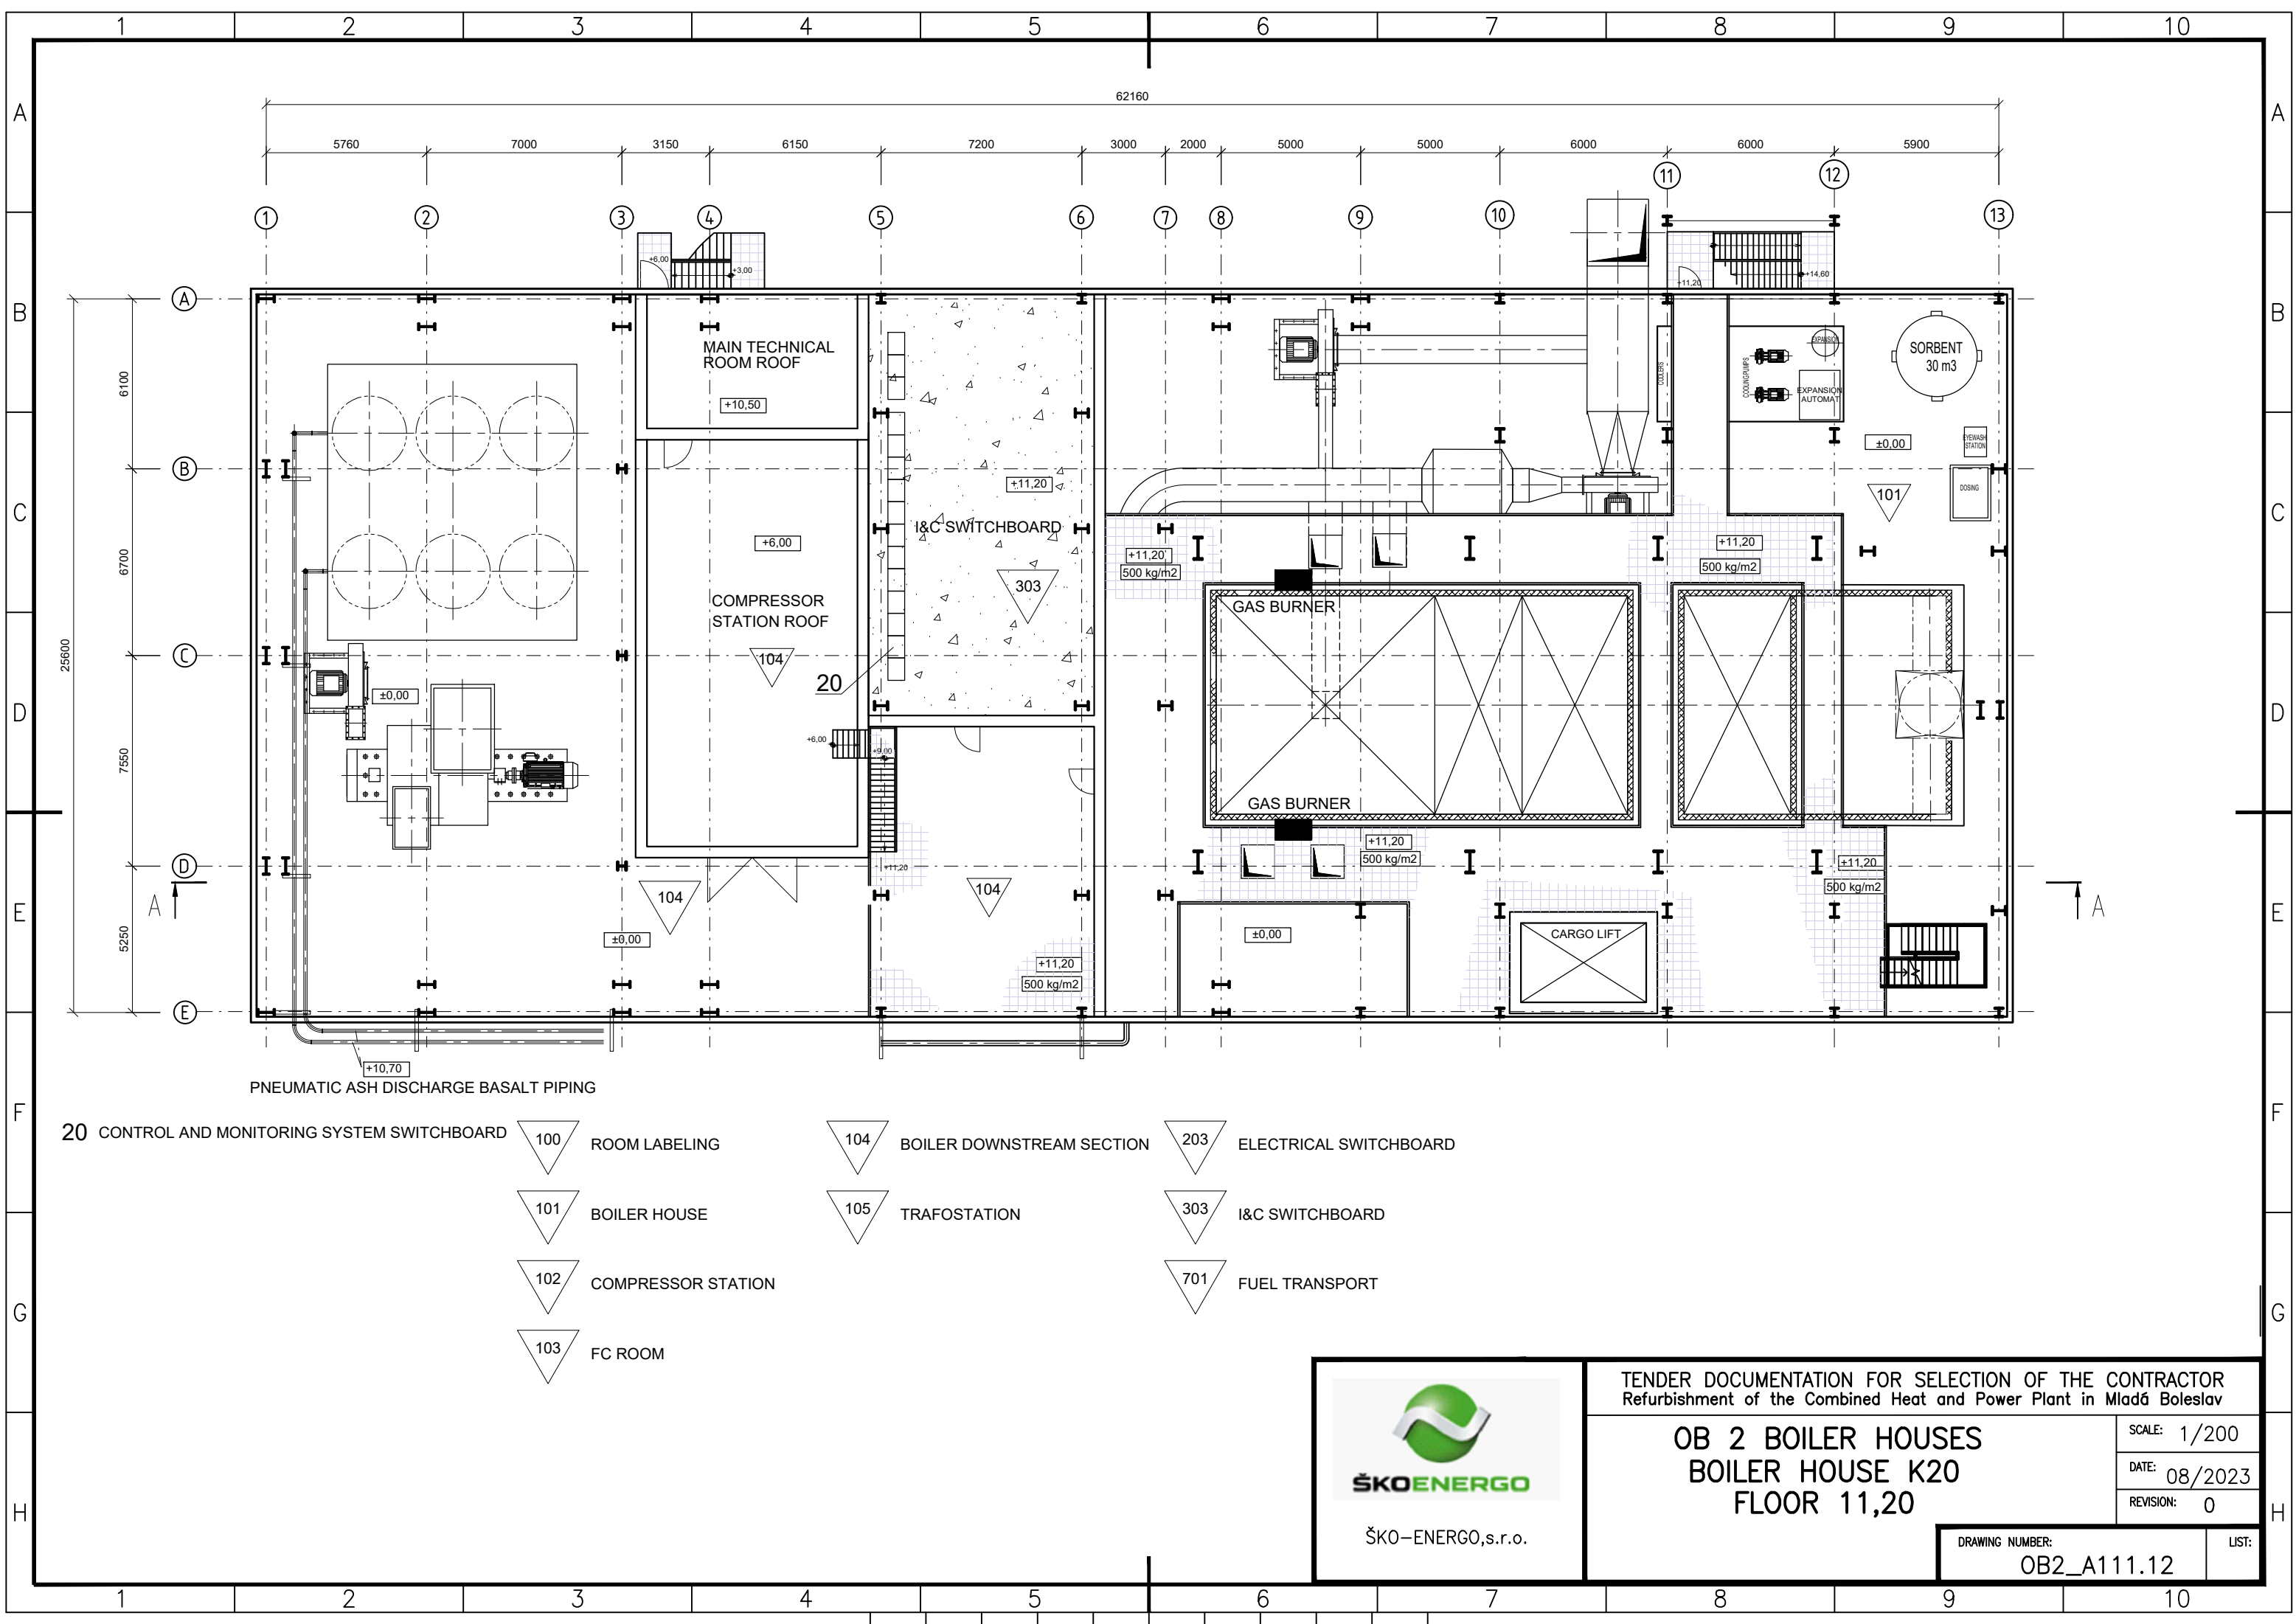

ŠKO-ENERGO,s.r.o.

TENDER DOCUMENTATION FOR SELECTION OF THE CONTRACTOR
Refurbishment of the Combined Heat and Power Plant in Mladá Boleslav

**OB 2 BOILER HOUSES
BOILER HOUSE K20
FLOOR 11,20**

SCALE: 1/200
DATE: 08/2023
REVISION: 0

DRAWING NUMBER:
OB2_A111.12

LIST: