


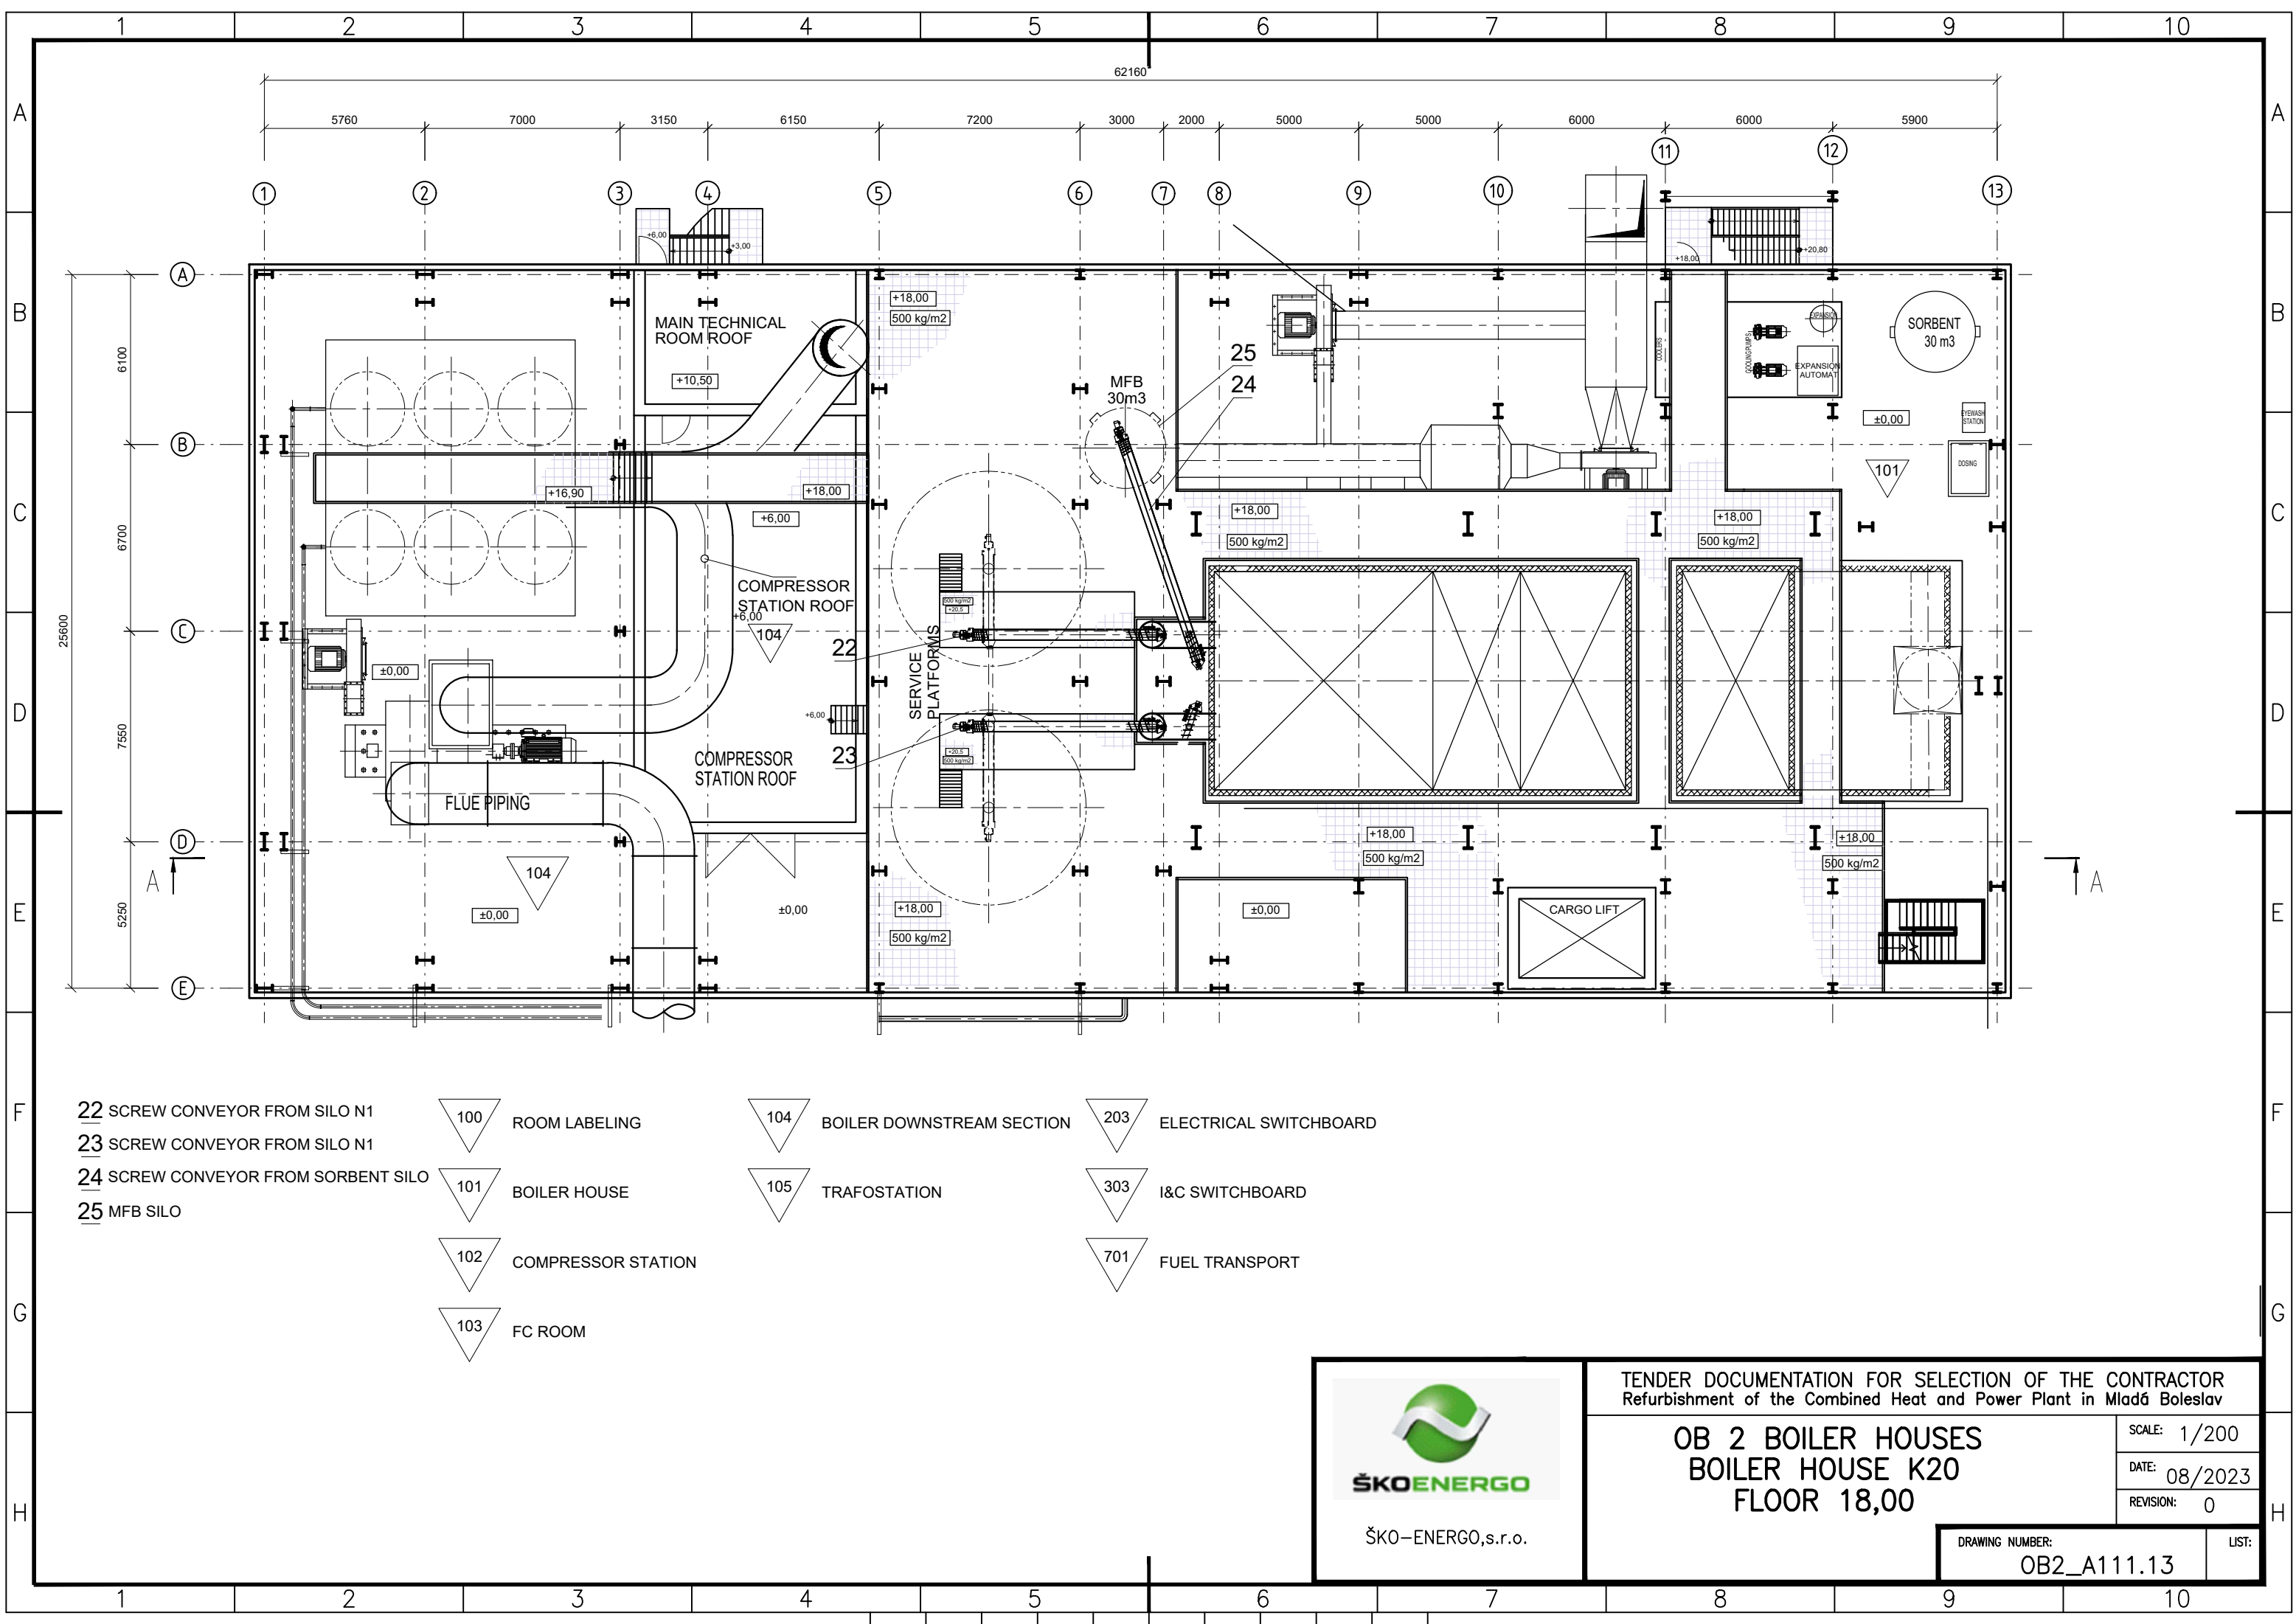

- 22 SCREW CONVEYOR FROM SILO N1
- 23 SCREW CONVEYOR FROM SILO N1
- 24 SCREW CONVEYOR FROM SORBENT SILO
- 25 MFB SILO

- 100 ROOM LABELING
- 101 BOILER HOUSE
- 102 COMPRESSOR STATION
- 103 FC ROOM

- 104 BOILER DOWNSTREAM SECTION
- 105 TRAFOSTATION

- 203 ELECTRICAL SWITCHBOARD
- 303 I&C SWITCHBOARD
- 701 FUEL TRANSPORT



ŠKO-ENERGO, s.r.o.

TENDER DOCUMENTATION FOR SELECTION OF THE CONTRACTOR
Refurbishment of the Combined Heat and Power Plant in Mladá Boleslav

OB 2 BOILER HOUSES
BOILER HOUSE K20
FLOOR 18,00

SCALE: 1/200

DATE: 08/2023

REVISION: 0

DRAWING NUMBER:
OB2_A111.13

LIST: