


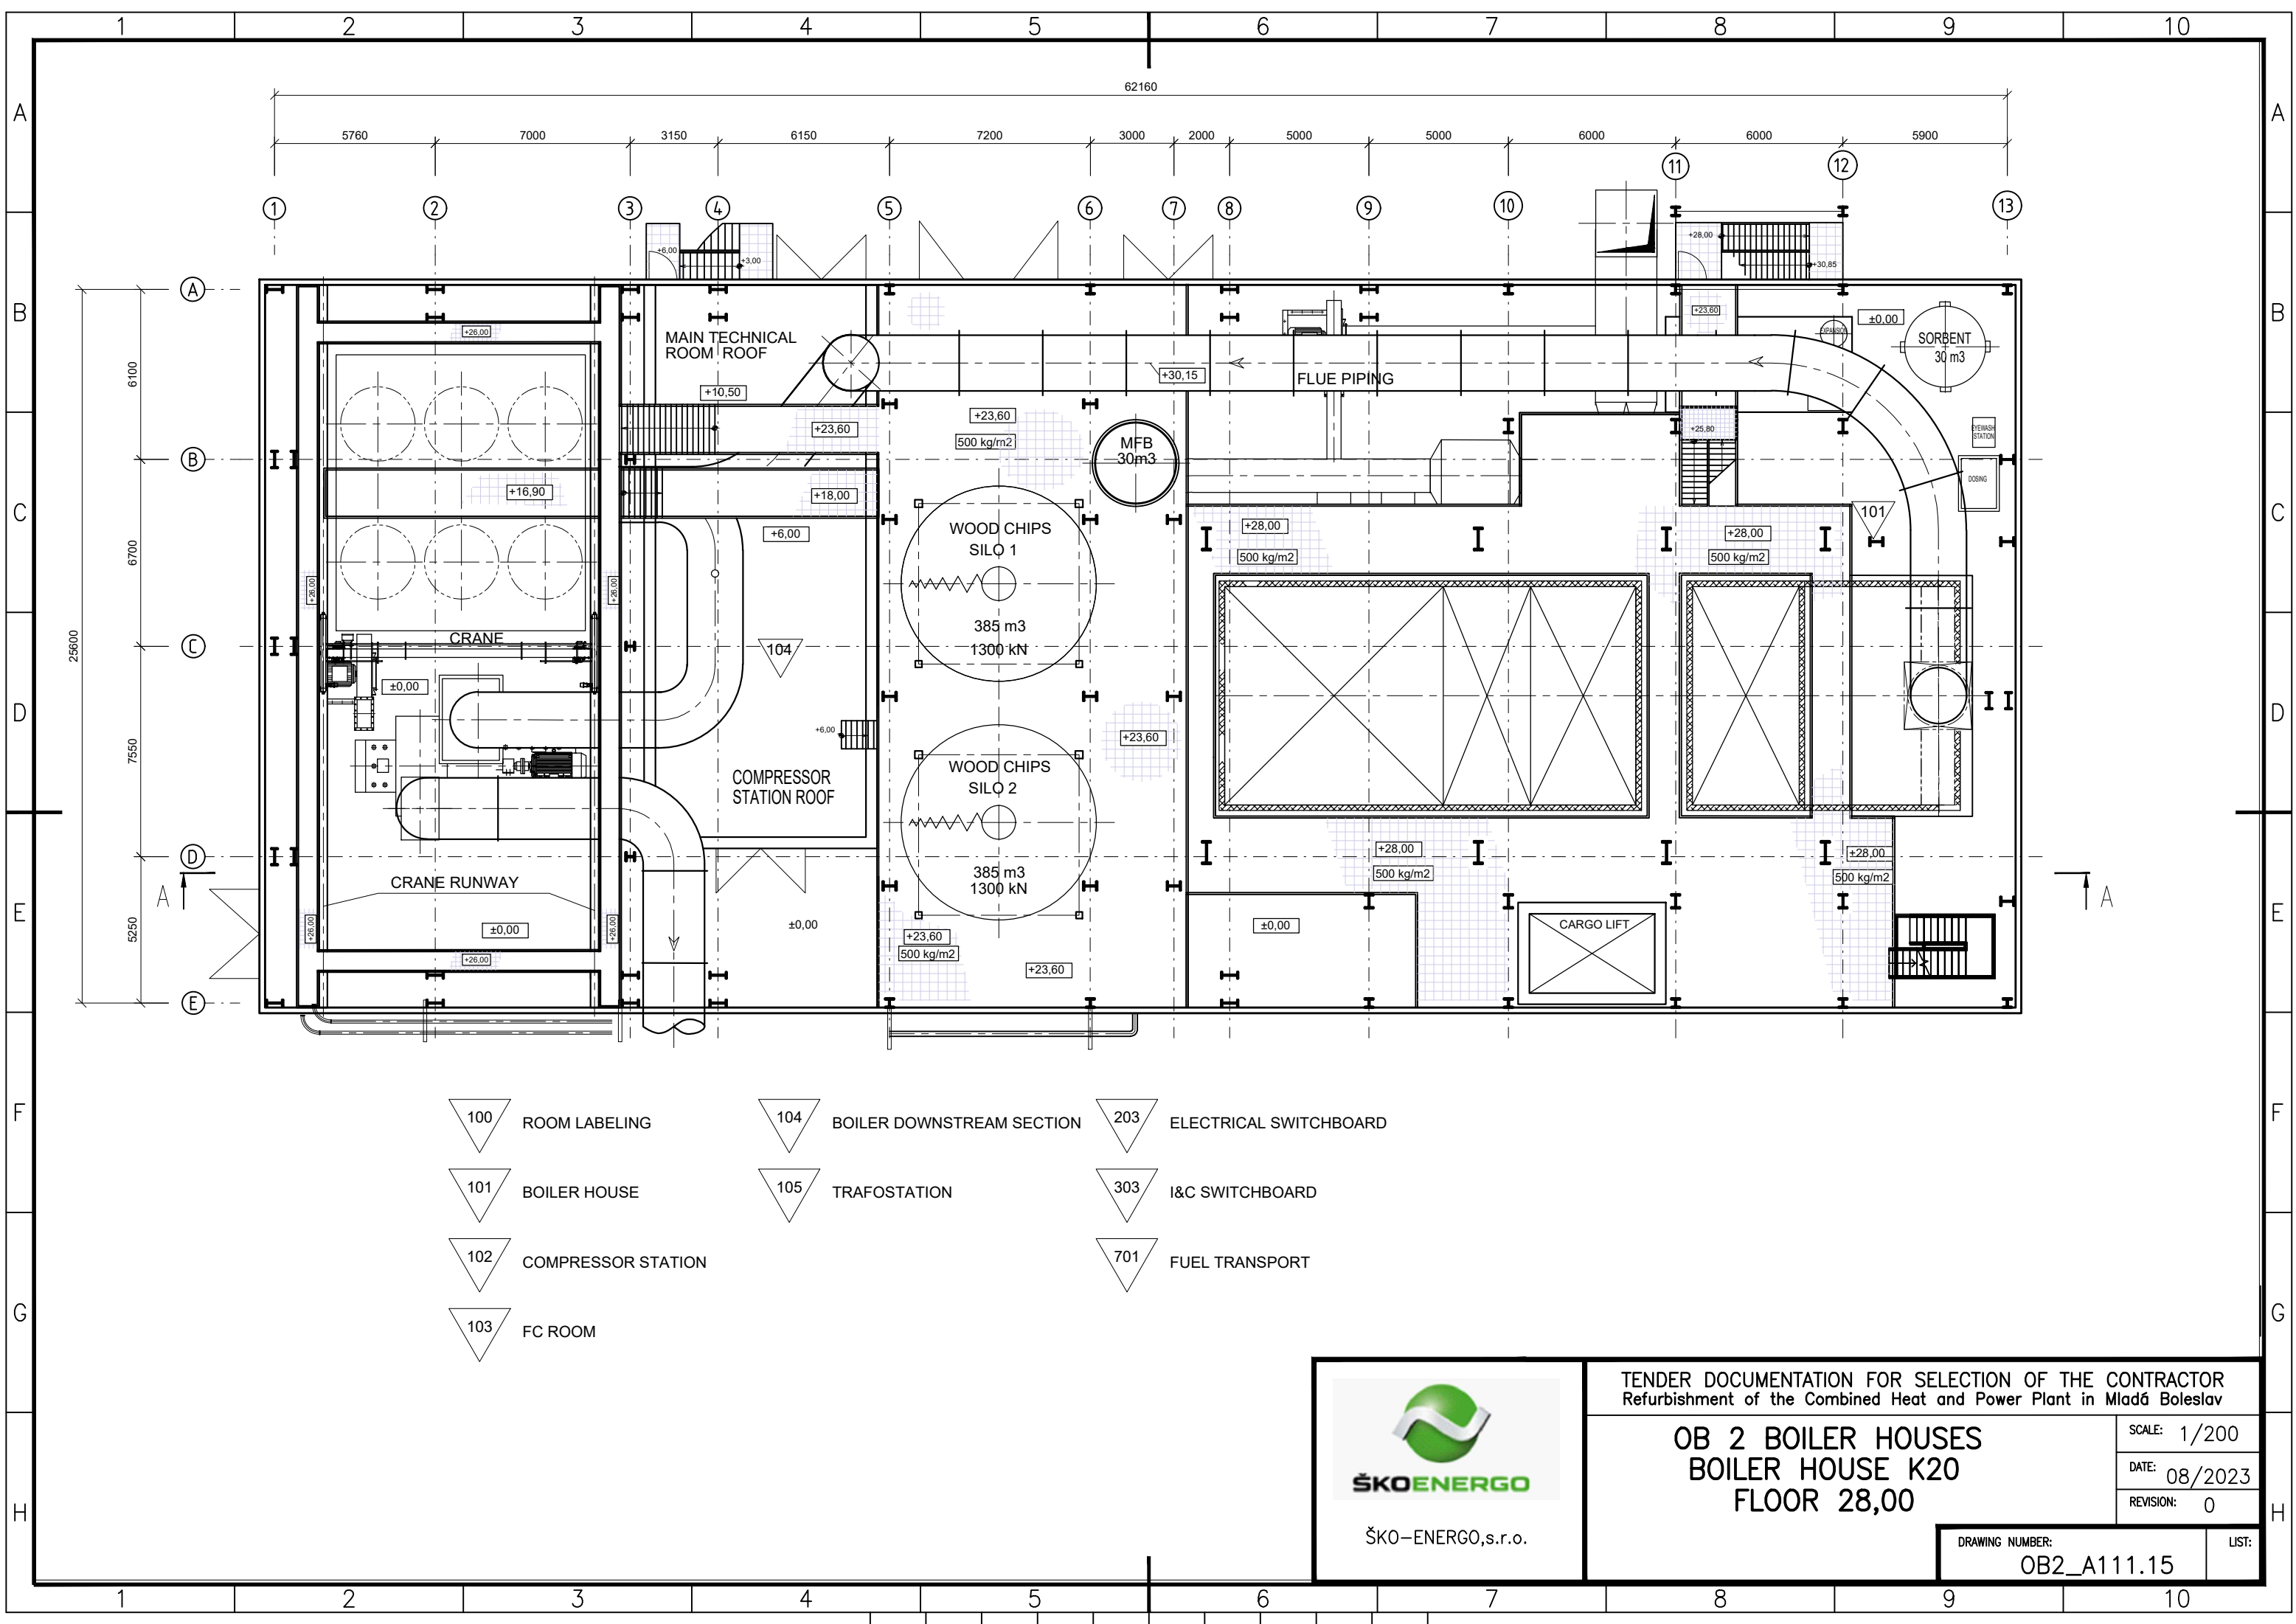

- | | | | | | |
|-----|--------------------|-----|---------------------------|-----|------------------------|
| 100 | ROOM LABELING | 104 | BOILER DOWNSTREAM SECTION | 203 | ELECTRICAL SWITCHBOARD |
| 101 | BOILER HOUSE | 105 | TRAFOSTATION | 303 | I&C SWITCHBOARD |
| 102 | COMPRESSOR STATION | | | 701 | FUEL TRANSPORT |
| 103 | FC ROOM | | | | |

 ŠKO-ENERGO,s.r.o.	TENDER DOCUMENTATION FOR SELECTION OF THE CONTRACTOR Refurbishment of the Combined Heat and Power Plant in Mladá Boleslav	
	OB 2 BOILER HOUSES BOILER HOUSE K20 FLOOR 28,00	
	SCALE: 1/200	DATE: 08/2023
	REVISION: 0	DRAWING NUMBER: OB2_A111.15