


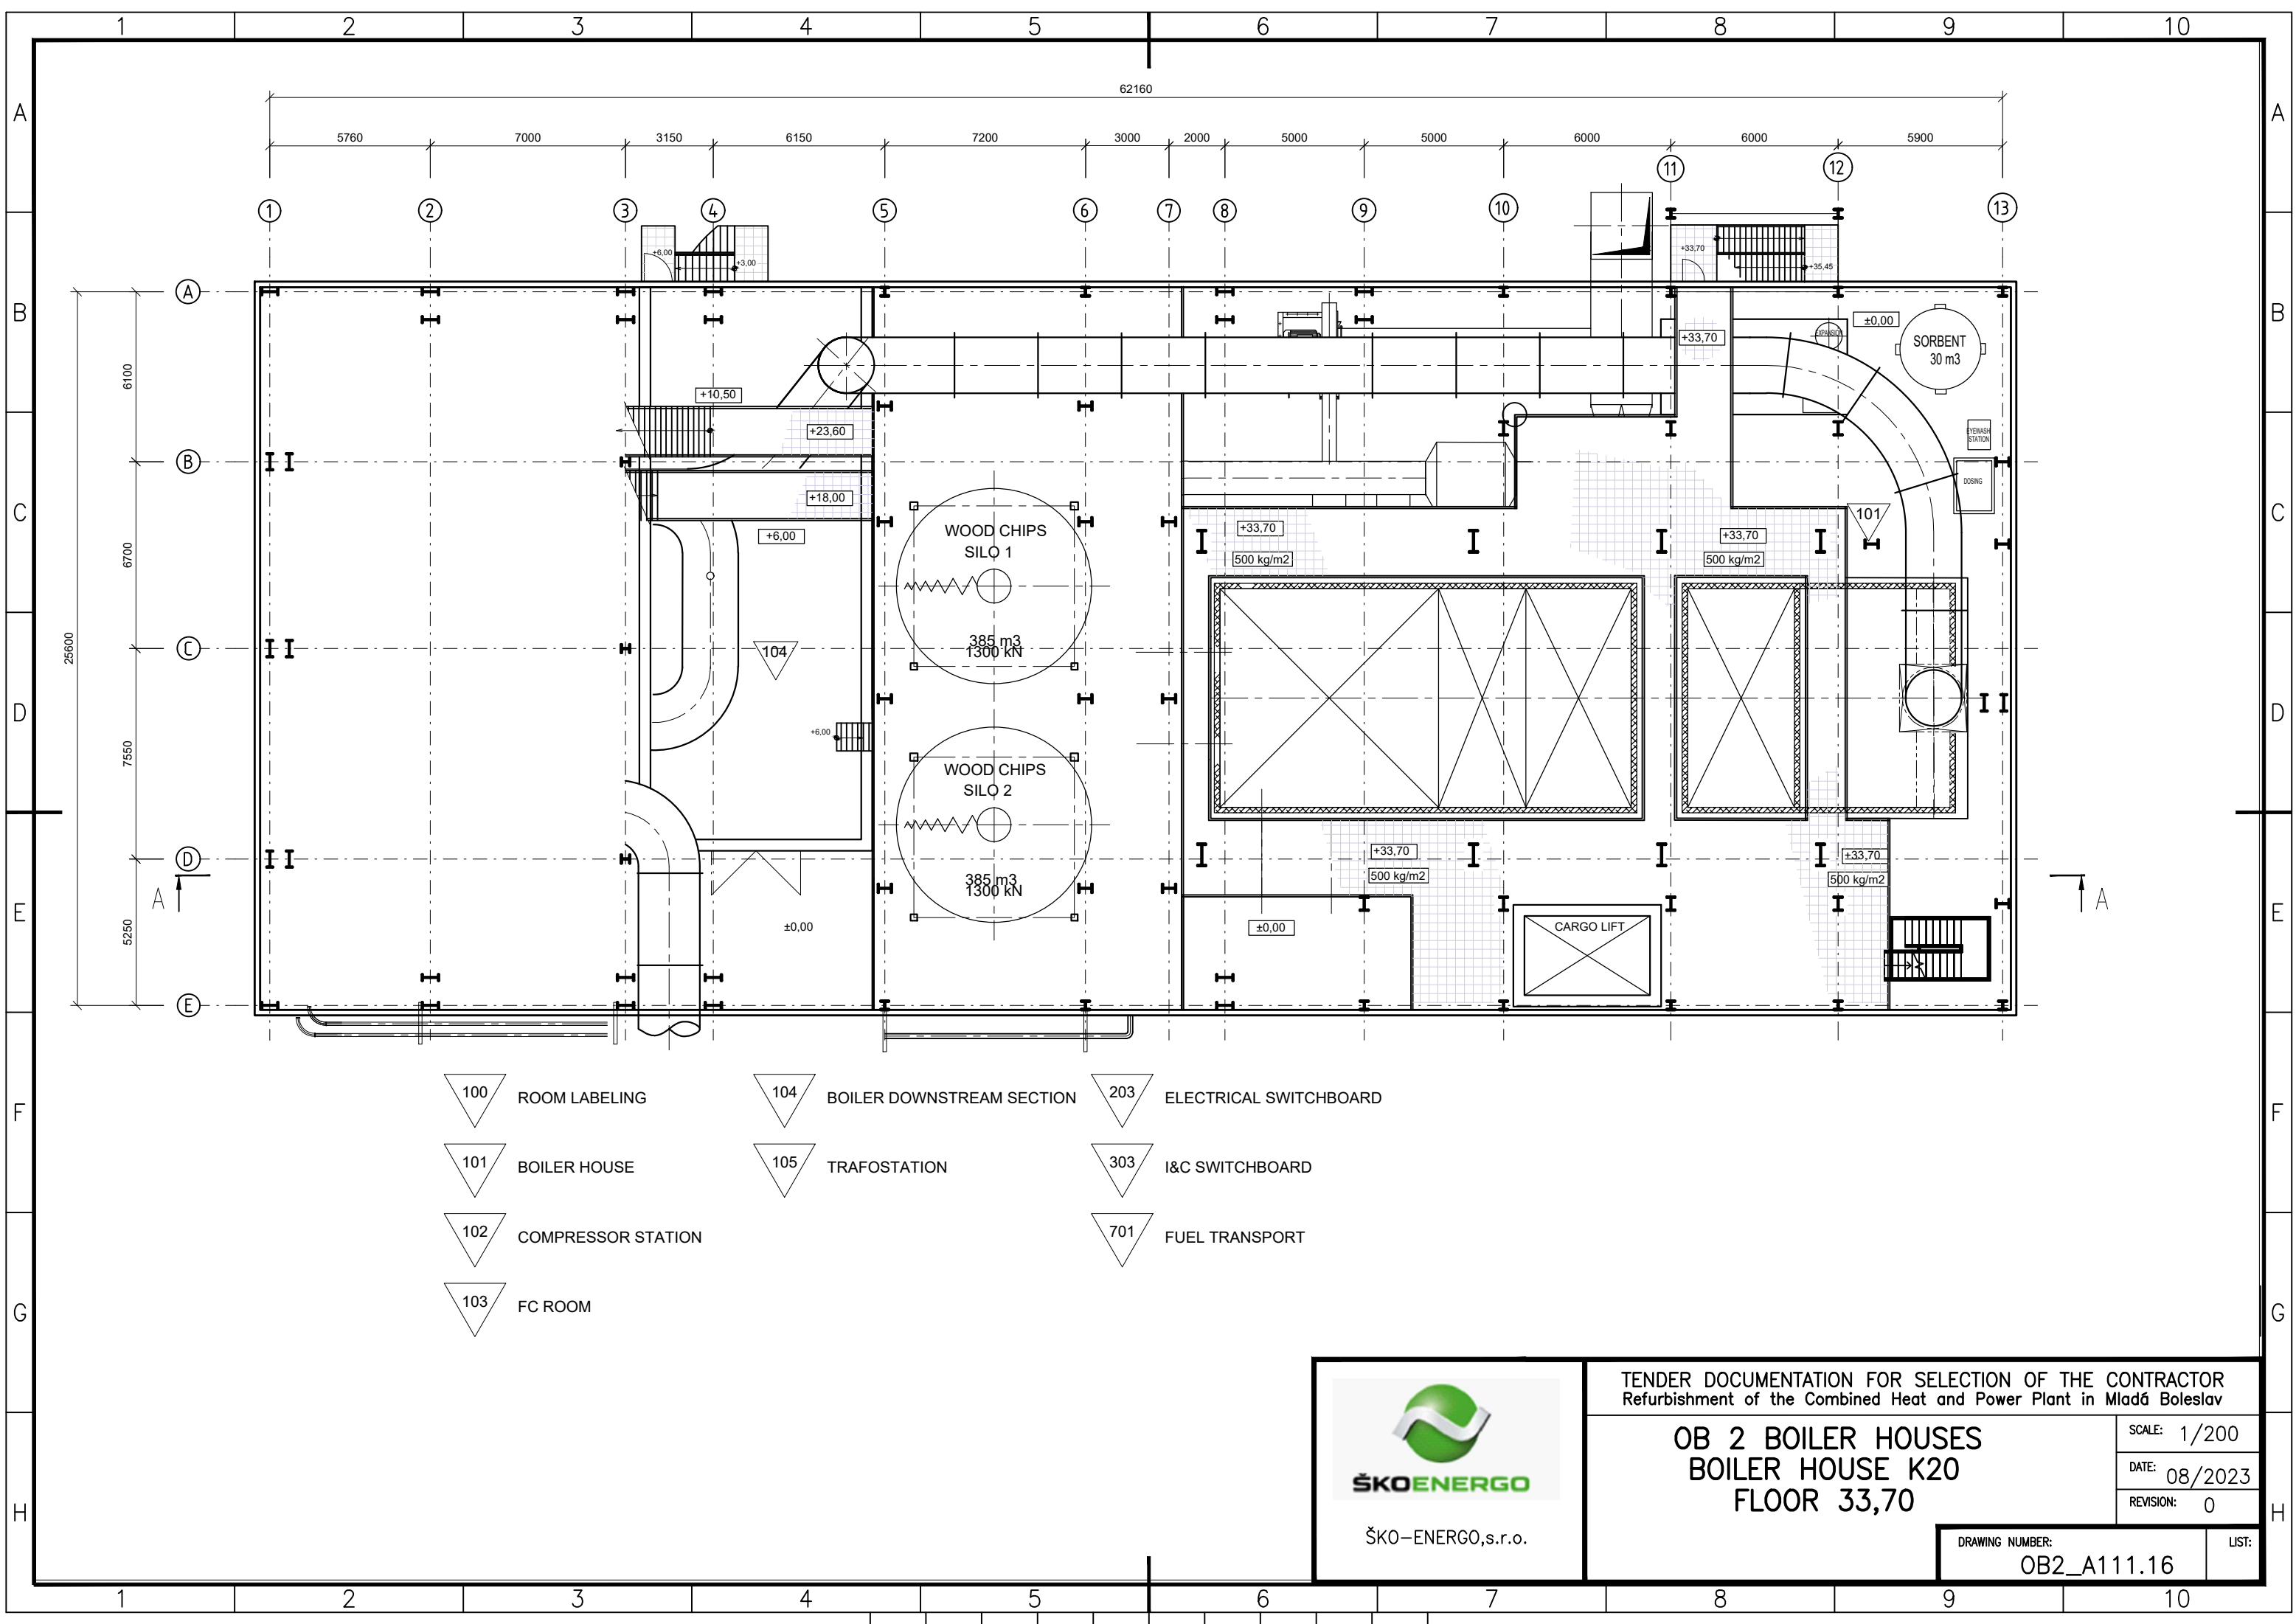

ŠKO-ENERGO,s.r.o.

TENDER DOCUMENTATION FOR SELECTION OF THE CONTRACTOR
Refurbishment of the Combined Heat and Power Plant in Mladá Boleslav

OB 2 BOILER HOUSES BOILER HOUSE K20 FLOOR 33,70

SCALE: 1/200
DATE: 08/2023
REVISION: 0

DRAWING NUMBER:
OB2_A111.16

LIST: