


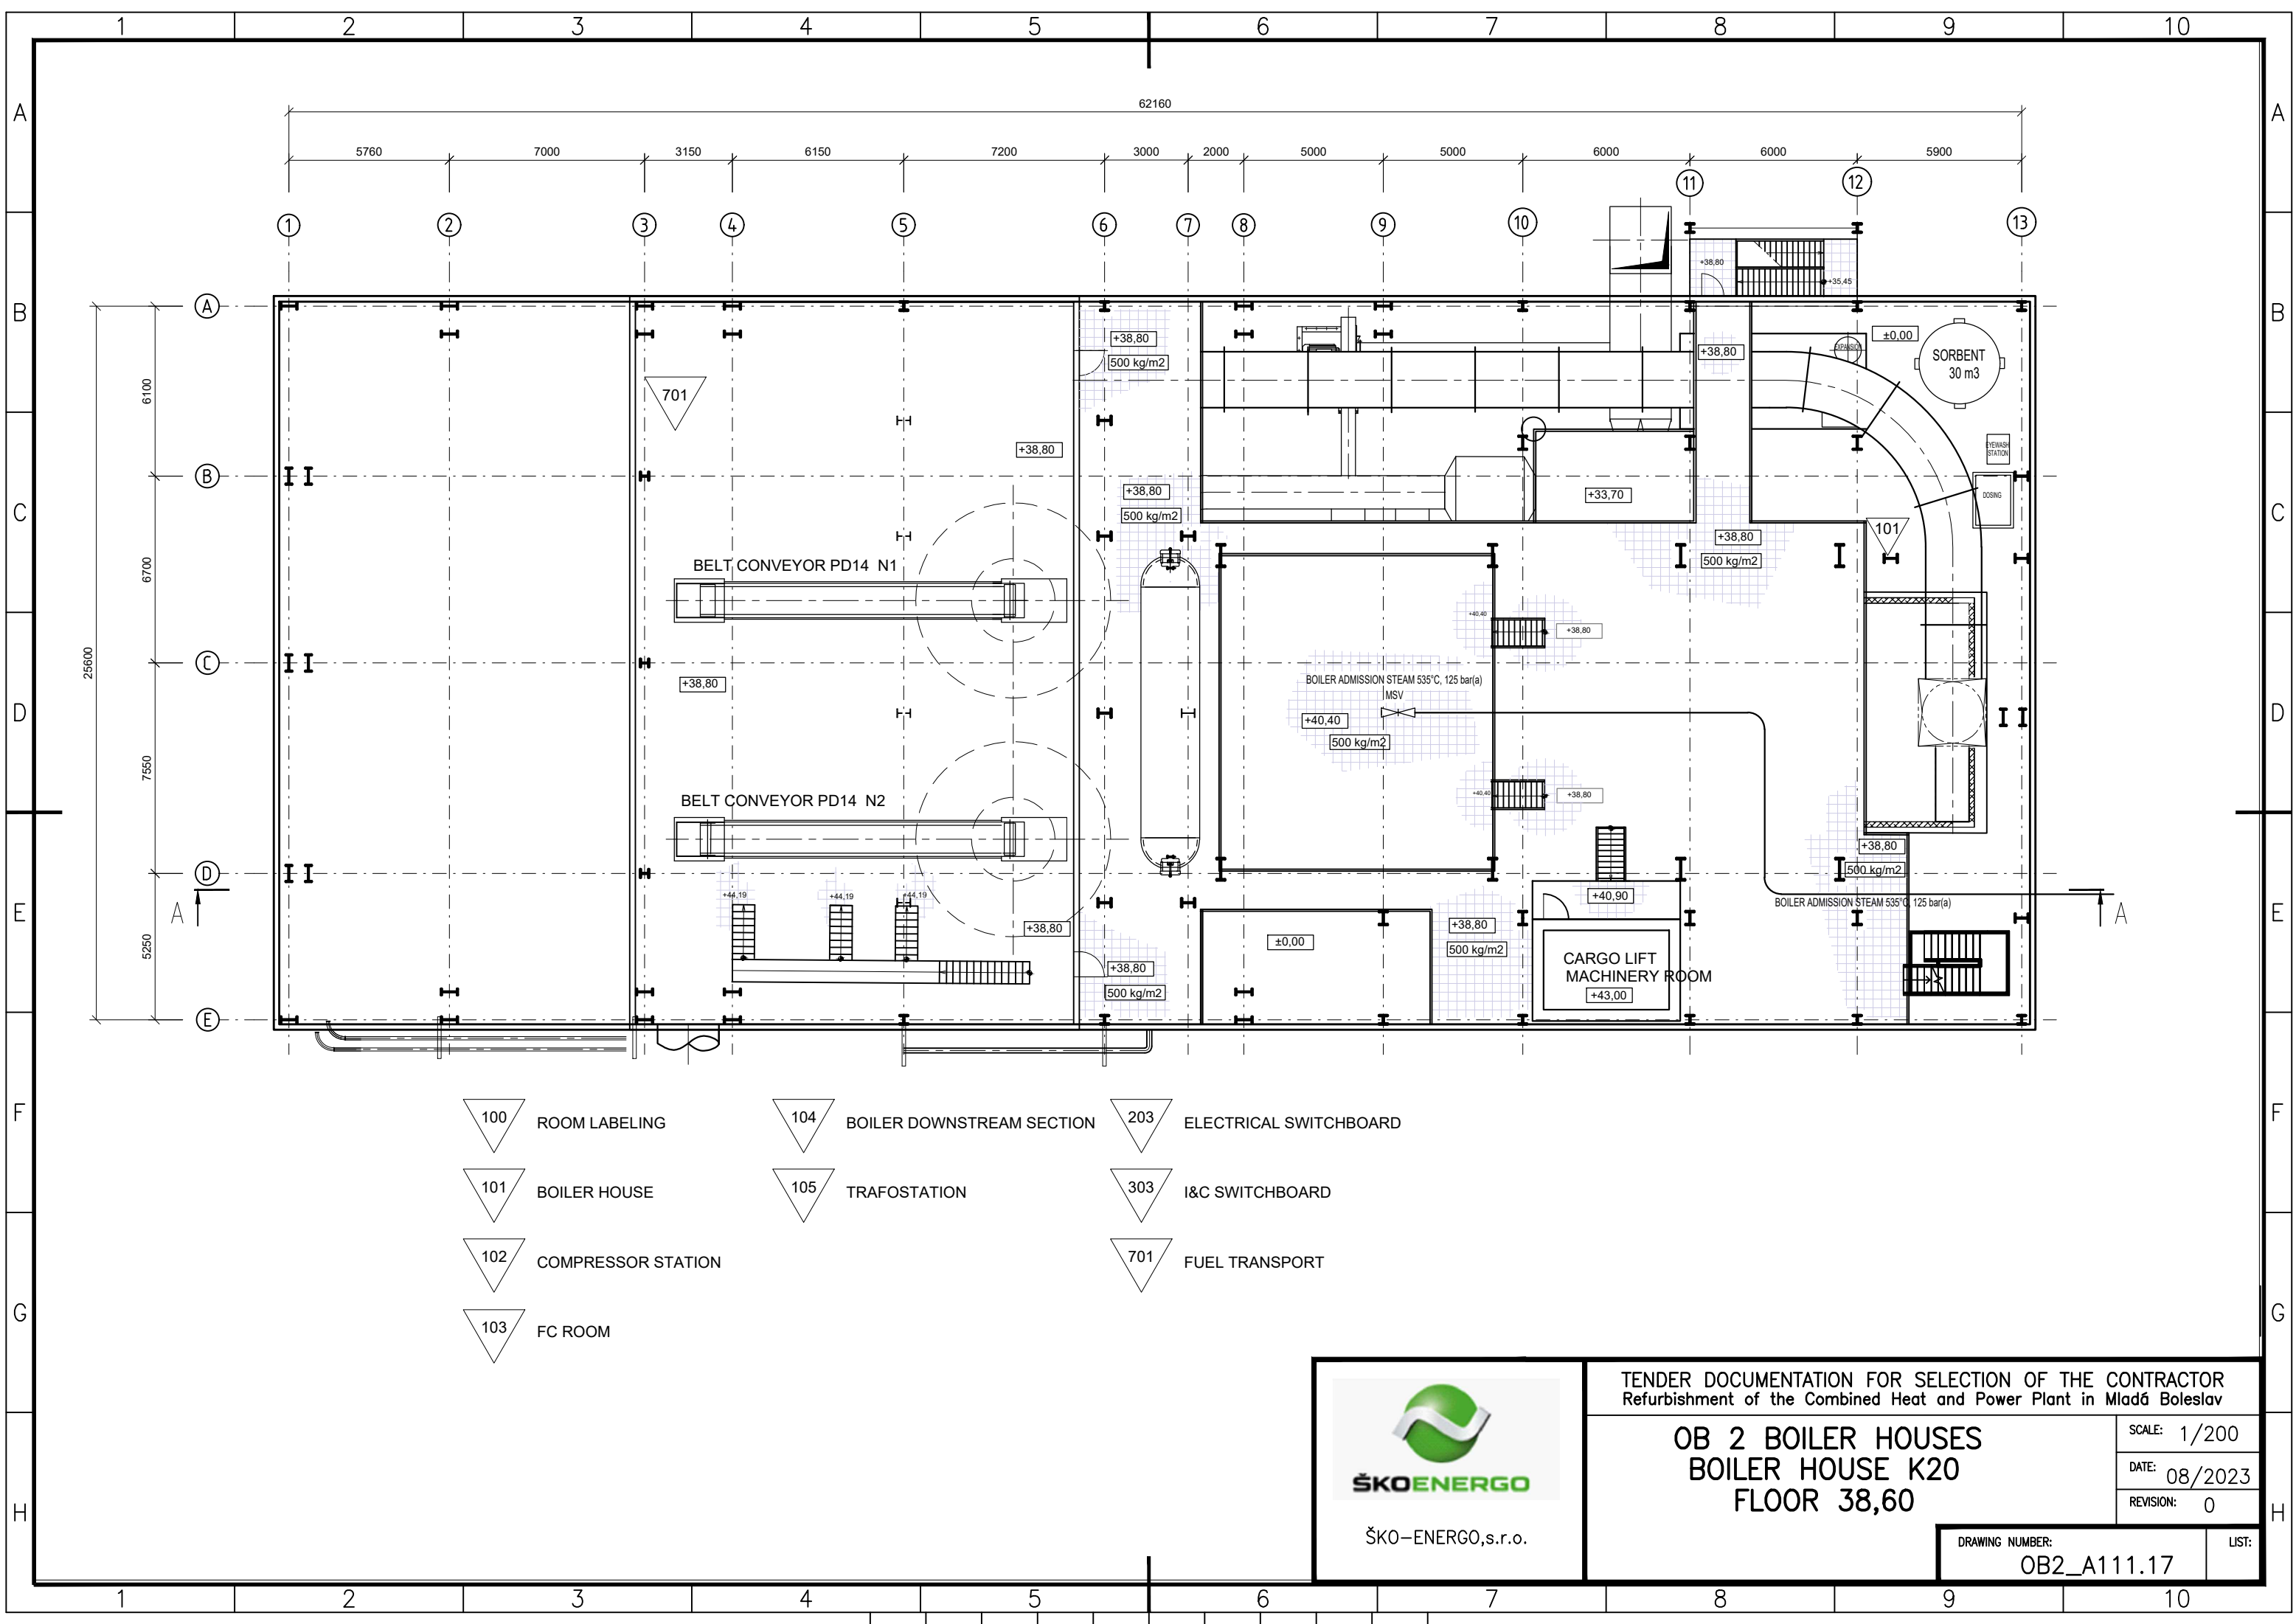

- | | | | | | |
|-----|--------------------|-----|---------------------------|-----|------------------------|
| 100 | ROOM LABELING | 104 | BOILER DOWNSTREAM SECTION | 203 | ELECTRICAL SWITCHBOARD |
| 101 | BOILER HOUSE | 105 | TRAFOSTATION | 303 | I&C SWITCHBOARD |
| 102 | COMPRESSOR STATION | | | 701 | FUEL TRANSPORT |
| 103 | FC ROOM | | | | |



ŠKO-ENERGO,s.r.o.

TENDER DOCUMENTATION FOR SELECTION OF THE CONTRACTOR
Refurbishment of the Combined Heat and Power Plant in Mladá Boleslav

OB 2 BOILER HOUSES
BOILER HOUSE K20
FLOOR 38,60

SCALE: 1/200
DATE: 08/2023
REVISION: 0

DRAWING NUMBER:
OB2_A111.17

LIST: