


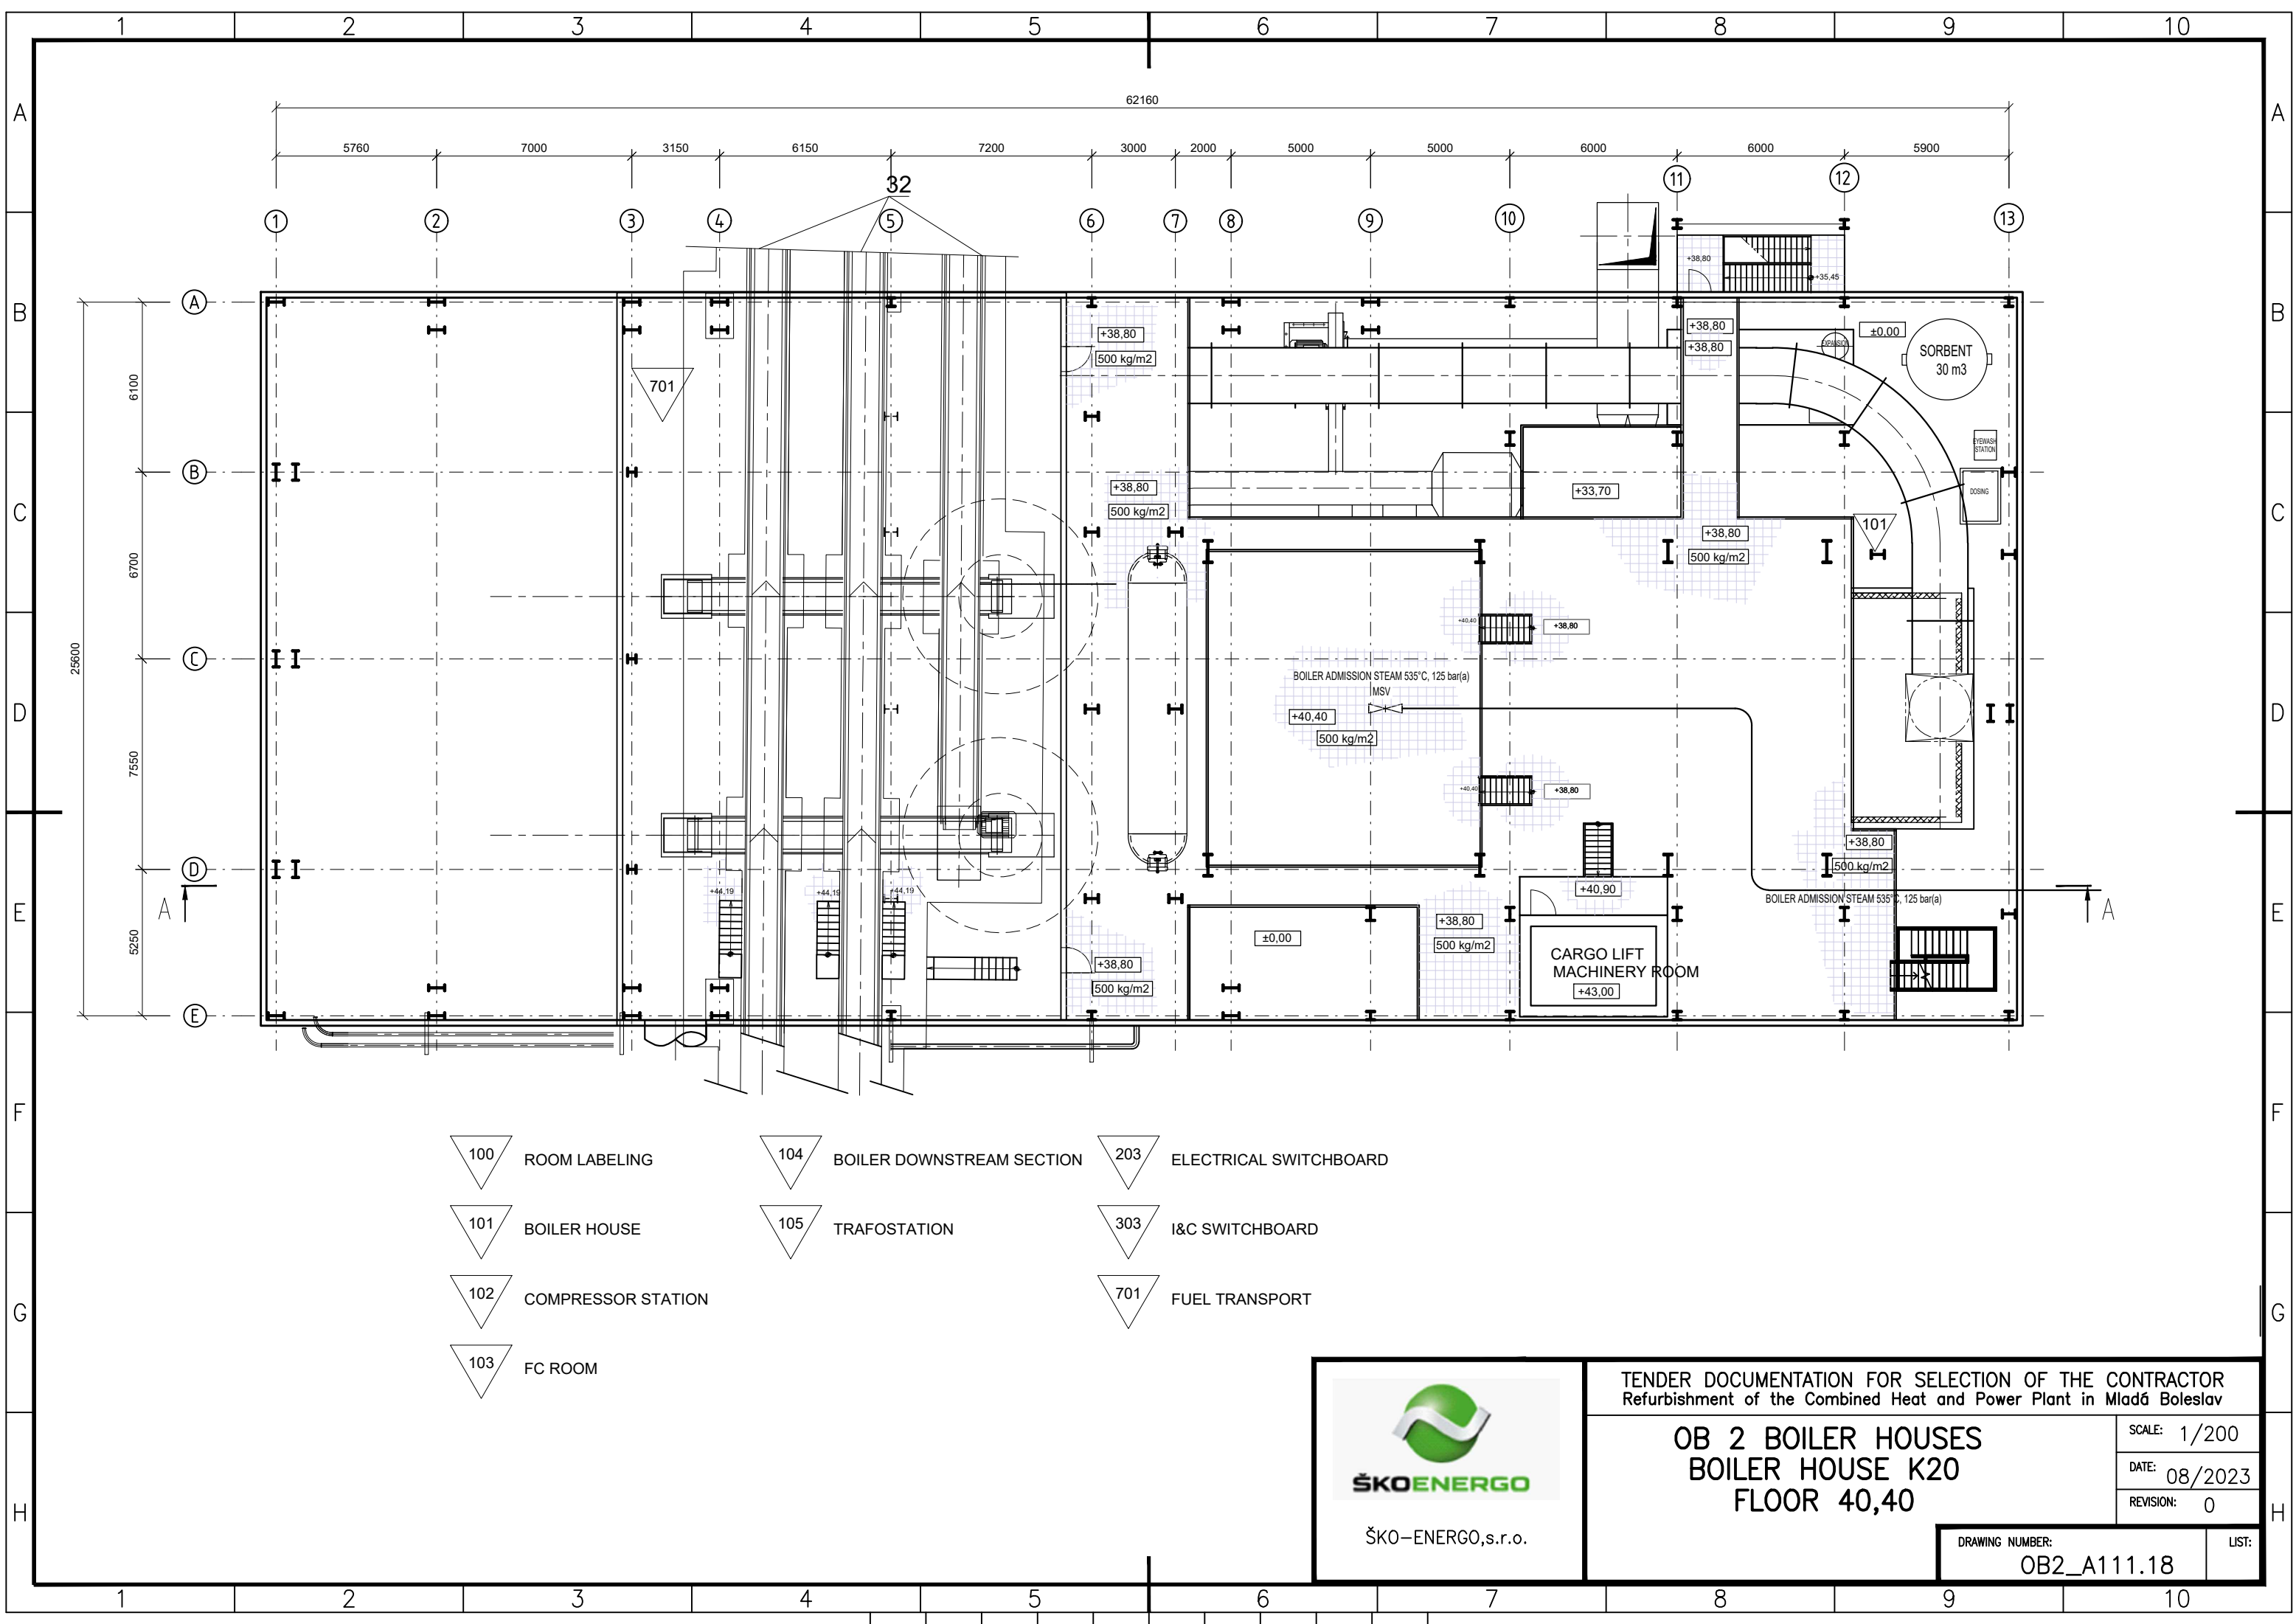

- | | | |
|------------------------|-------------------------------|----------------------------|
| 100 ROOM LABELING | 104 BOILER DOWNSTREAM SECTION | 203 ELECTRICAL SWITCHBOARD |
| 101 BOILER HOUSE | 105 TRAFOSTATION | 303 I&C SWITCHBOARD |
| 102 COMPRESSOR STATION | | 701 FUEL TRANSPORT |
| 103 FC ROOM | | |

 ŠKO-ENERGO,s.r.o.	TENDER DOCUMENTATION FOR SELECTION OF THE CONTRACTOR Refurbishment of the Combined Heat and Power Plant in Mladá Boleslav	
	OB 2 BOILER HOUSES BOILER HOUSE K20 FLOOR 40,40	
	SCALE: 1/200	DATE: 08/2023
	REVISION: 0	DRAWING NUMBER: OB2_A111.18
		LIST: