


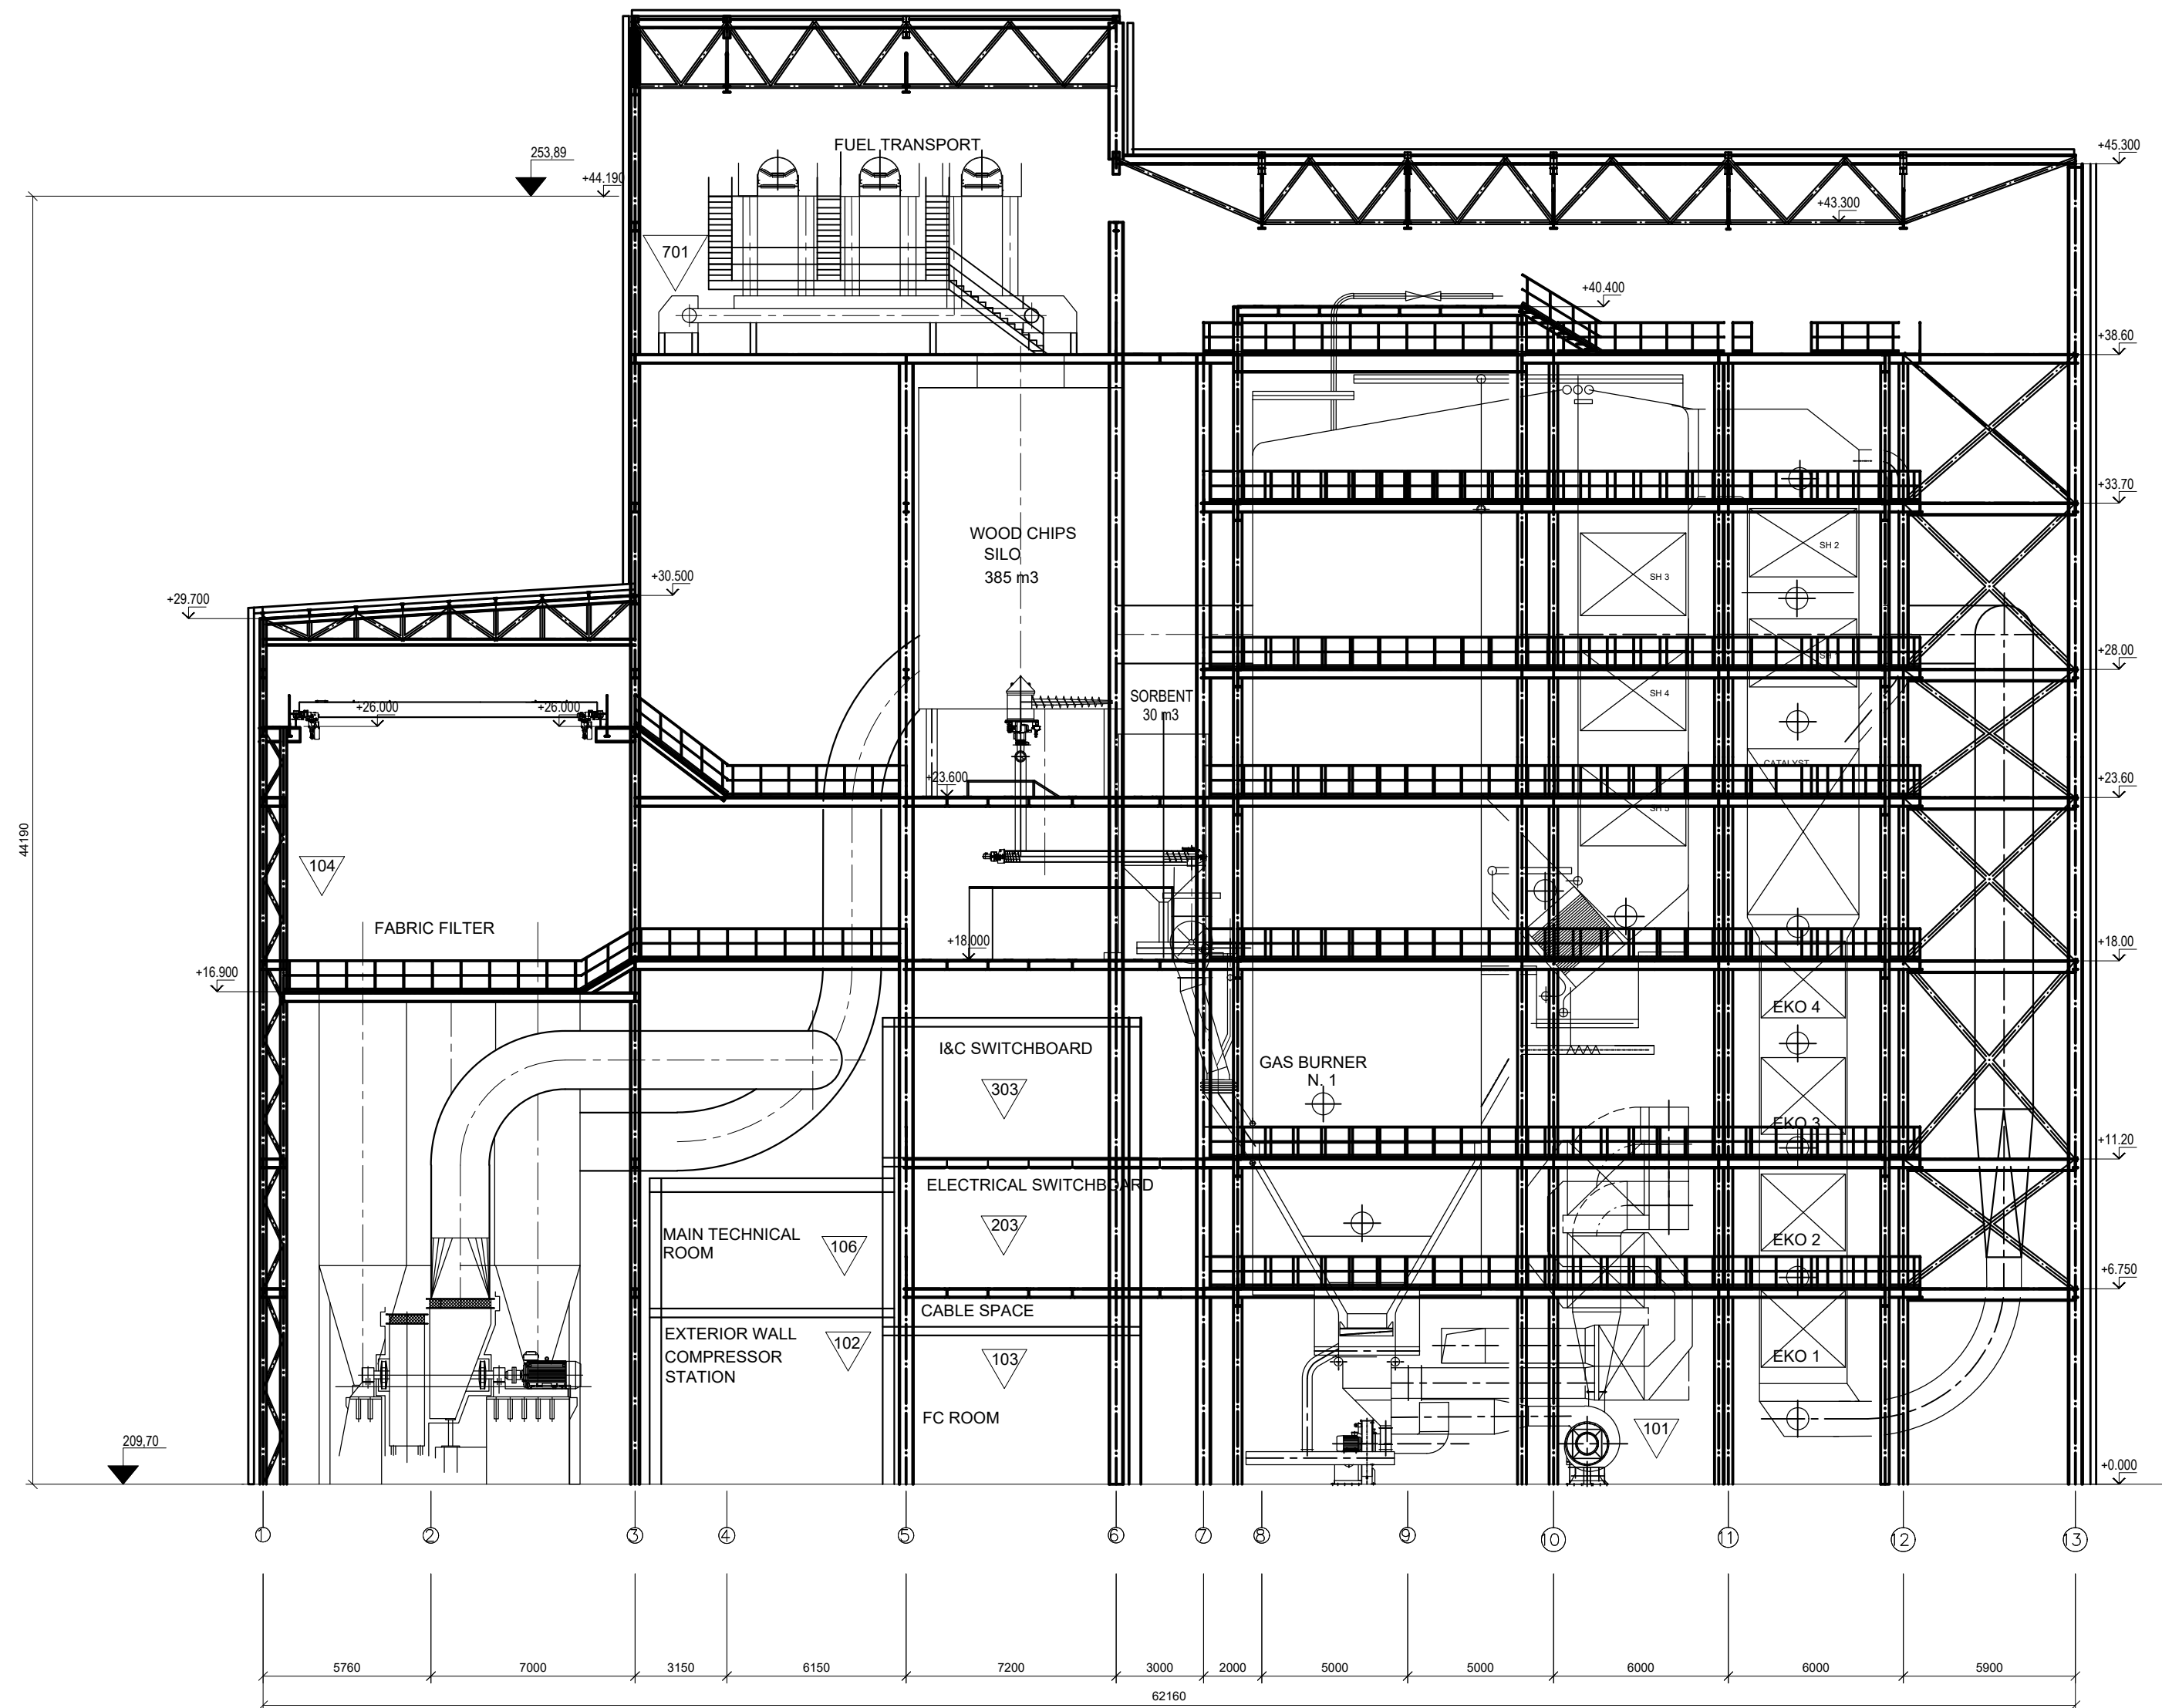

- 100 ROOM LABELING
- 101 BOILER HOUSE
- 102 COMPRESSOR STATION
- 103 FC ROOM
- 104 BOILER DOWNSTREAM SECTION
- 105 TRAFOSTATION
- 106 MAIN TECHNICAL ROOM
- 203 ELECTRICAL SWITCHBOARD
- 303 I&C SWITCHBOARD
- 701 FUEL TRANSPORT

±0,00=209,70

 ŠKO-ENERGO,s.r.o.	TENDER DOCUMENTATION FOR SELECTION OF THE CONTRACTOR Refurbishment of the Combined Heat and Power Plant in Mladá Boleslav	
	OB 2 BOILER HOUSES BOILER HOUSE K20 SECTION A-A	SCALE: 1/200
		DATE: 08/2023
		REVISION: 0
DRAWING NUMBER: OB2_A111.19		LIST: