


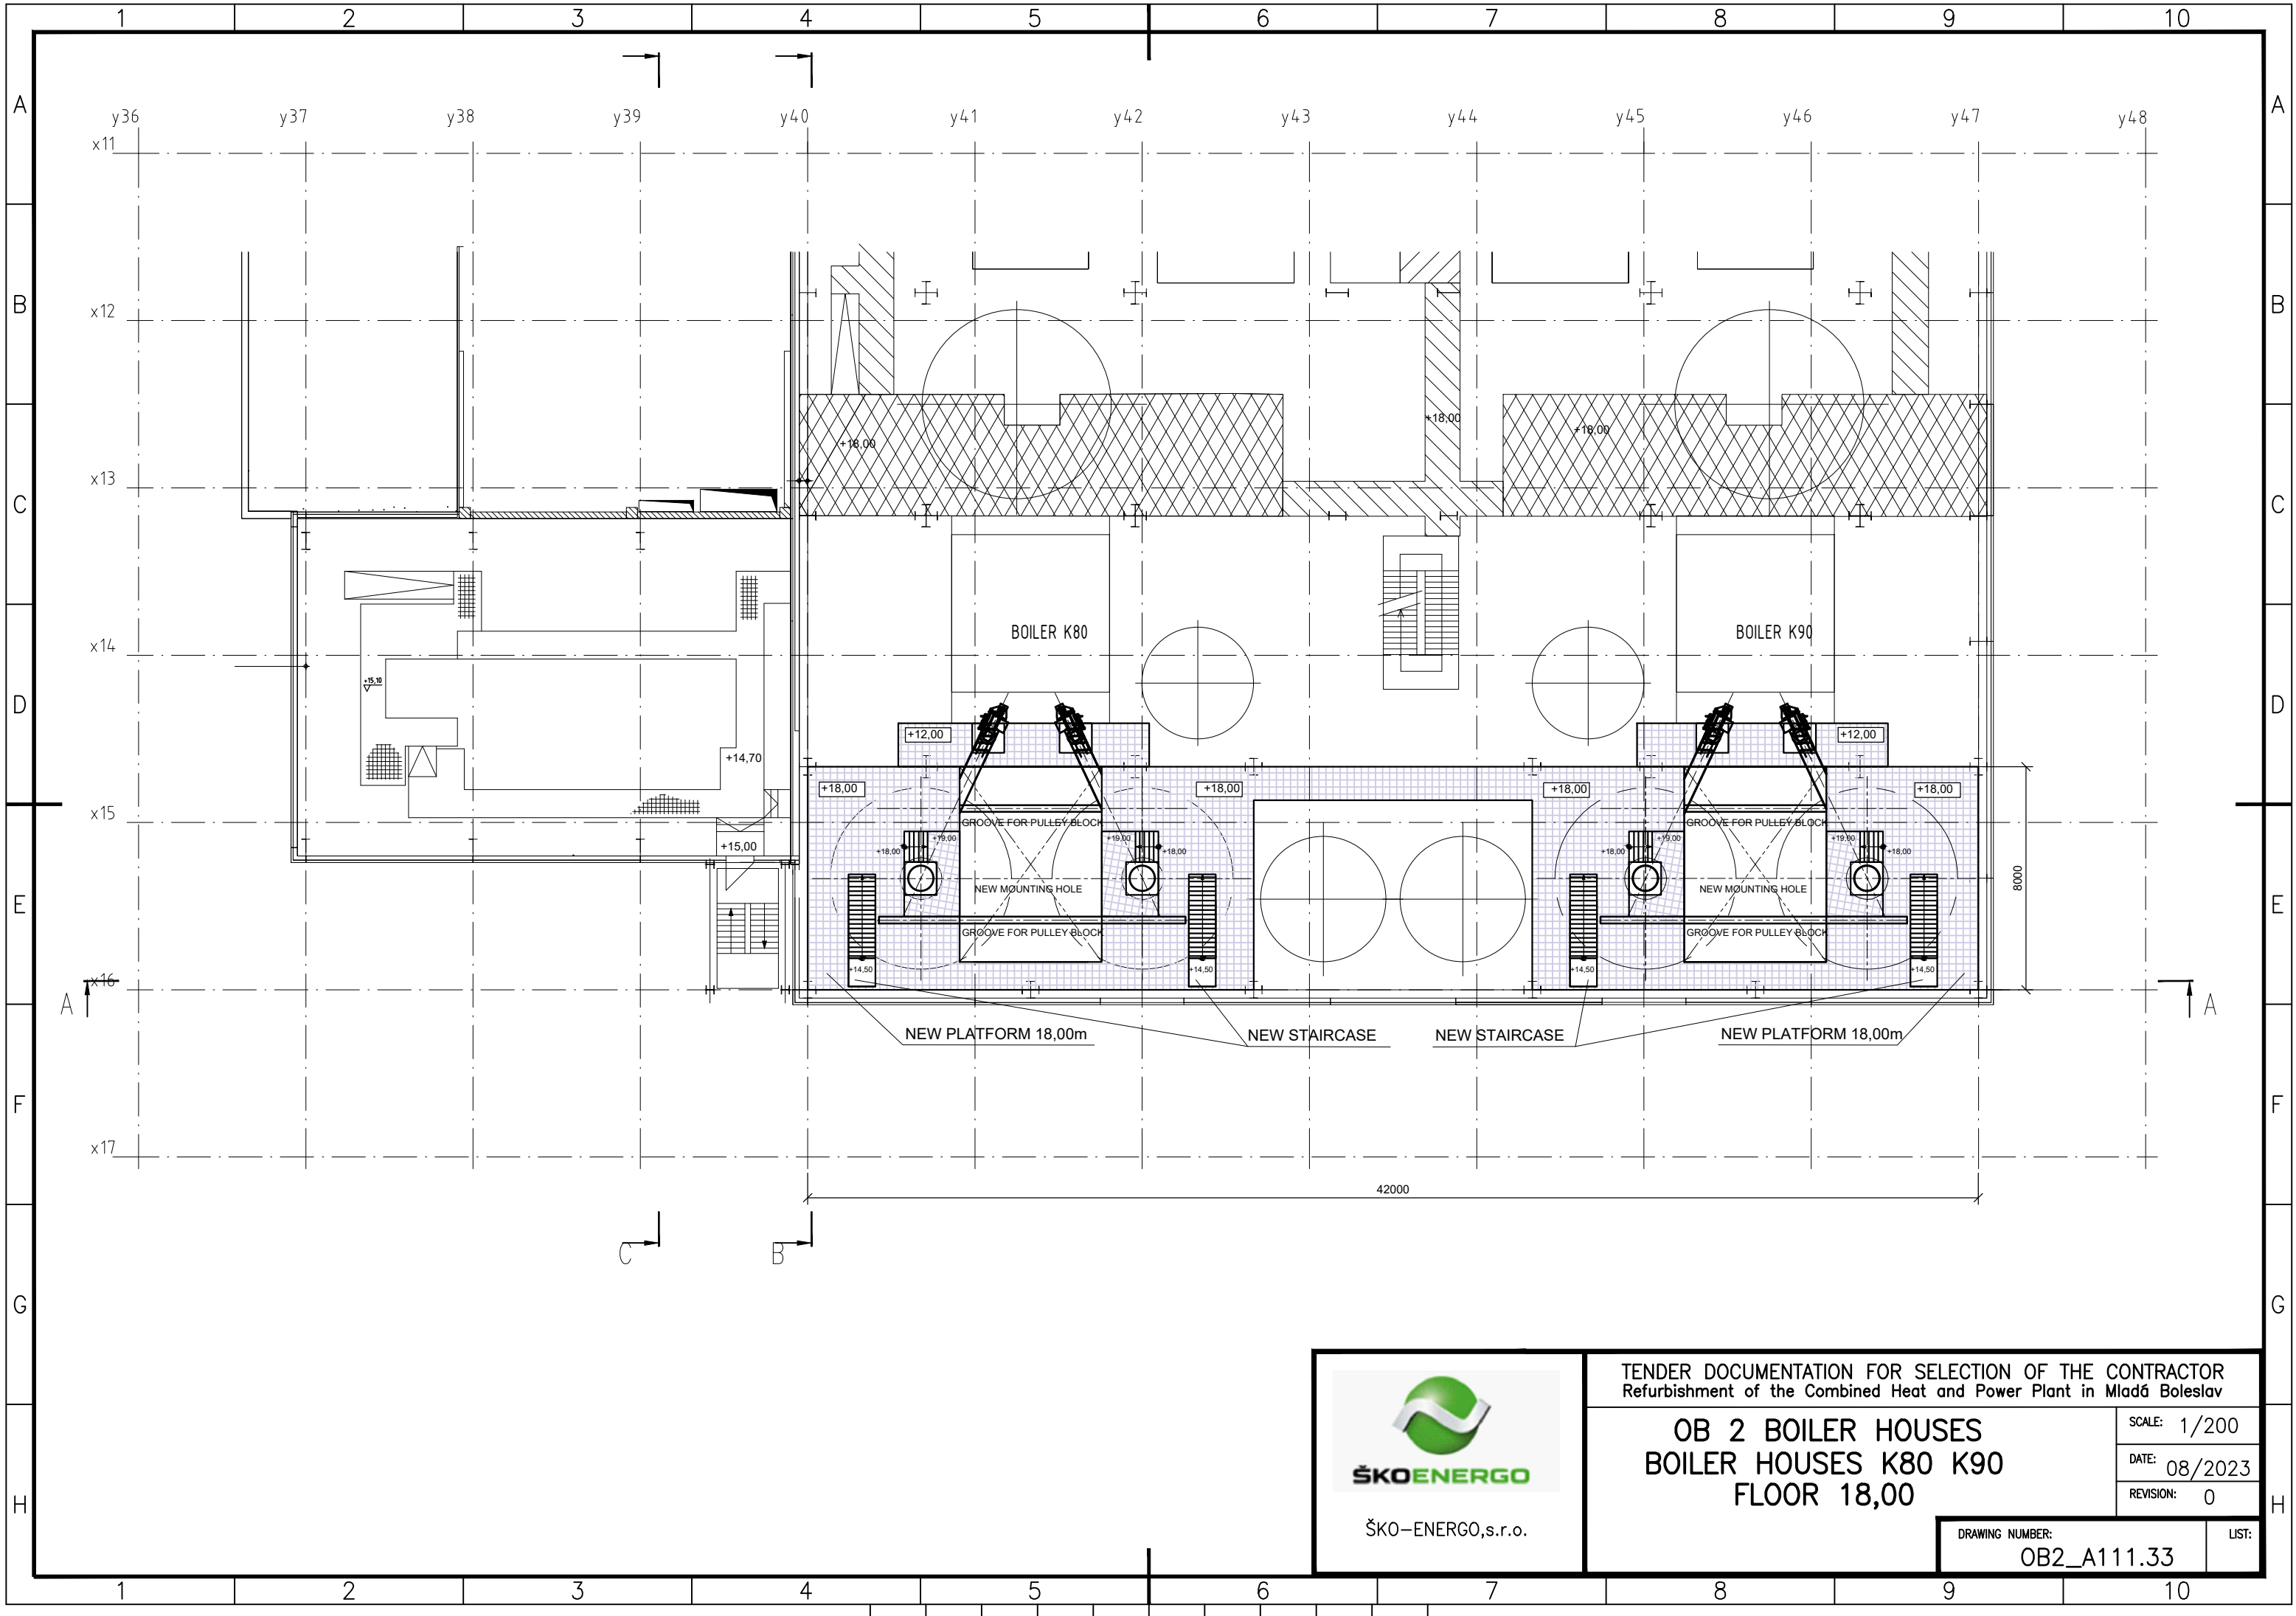

ŠKO-ENERGO,s.r.o.

TENDER DOCUMENTATION FOR SELECTION OF THE CONTRACTOR
Refurbishment of the Combined Heat and Power Plant in Mladá Boleslav

**OB 2 BOILER HOUSES
BOILER HOUSES K80 K90
FLOOR 18,00**

SCALE: 1/200
DATE: 08/2023
REVISION: 0

DRAWING NUMBER: OB2_A111.33	LIST:
---------------------------------------	-------