


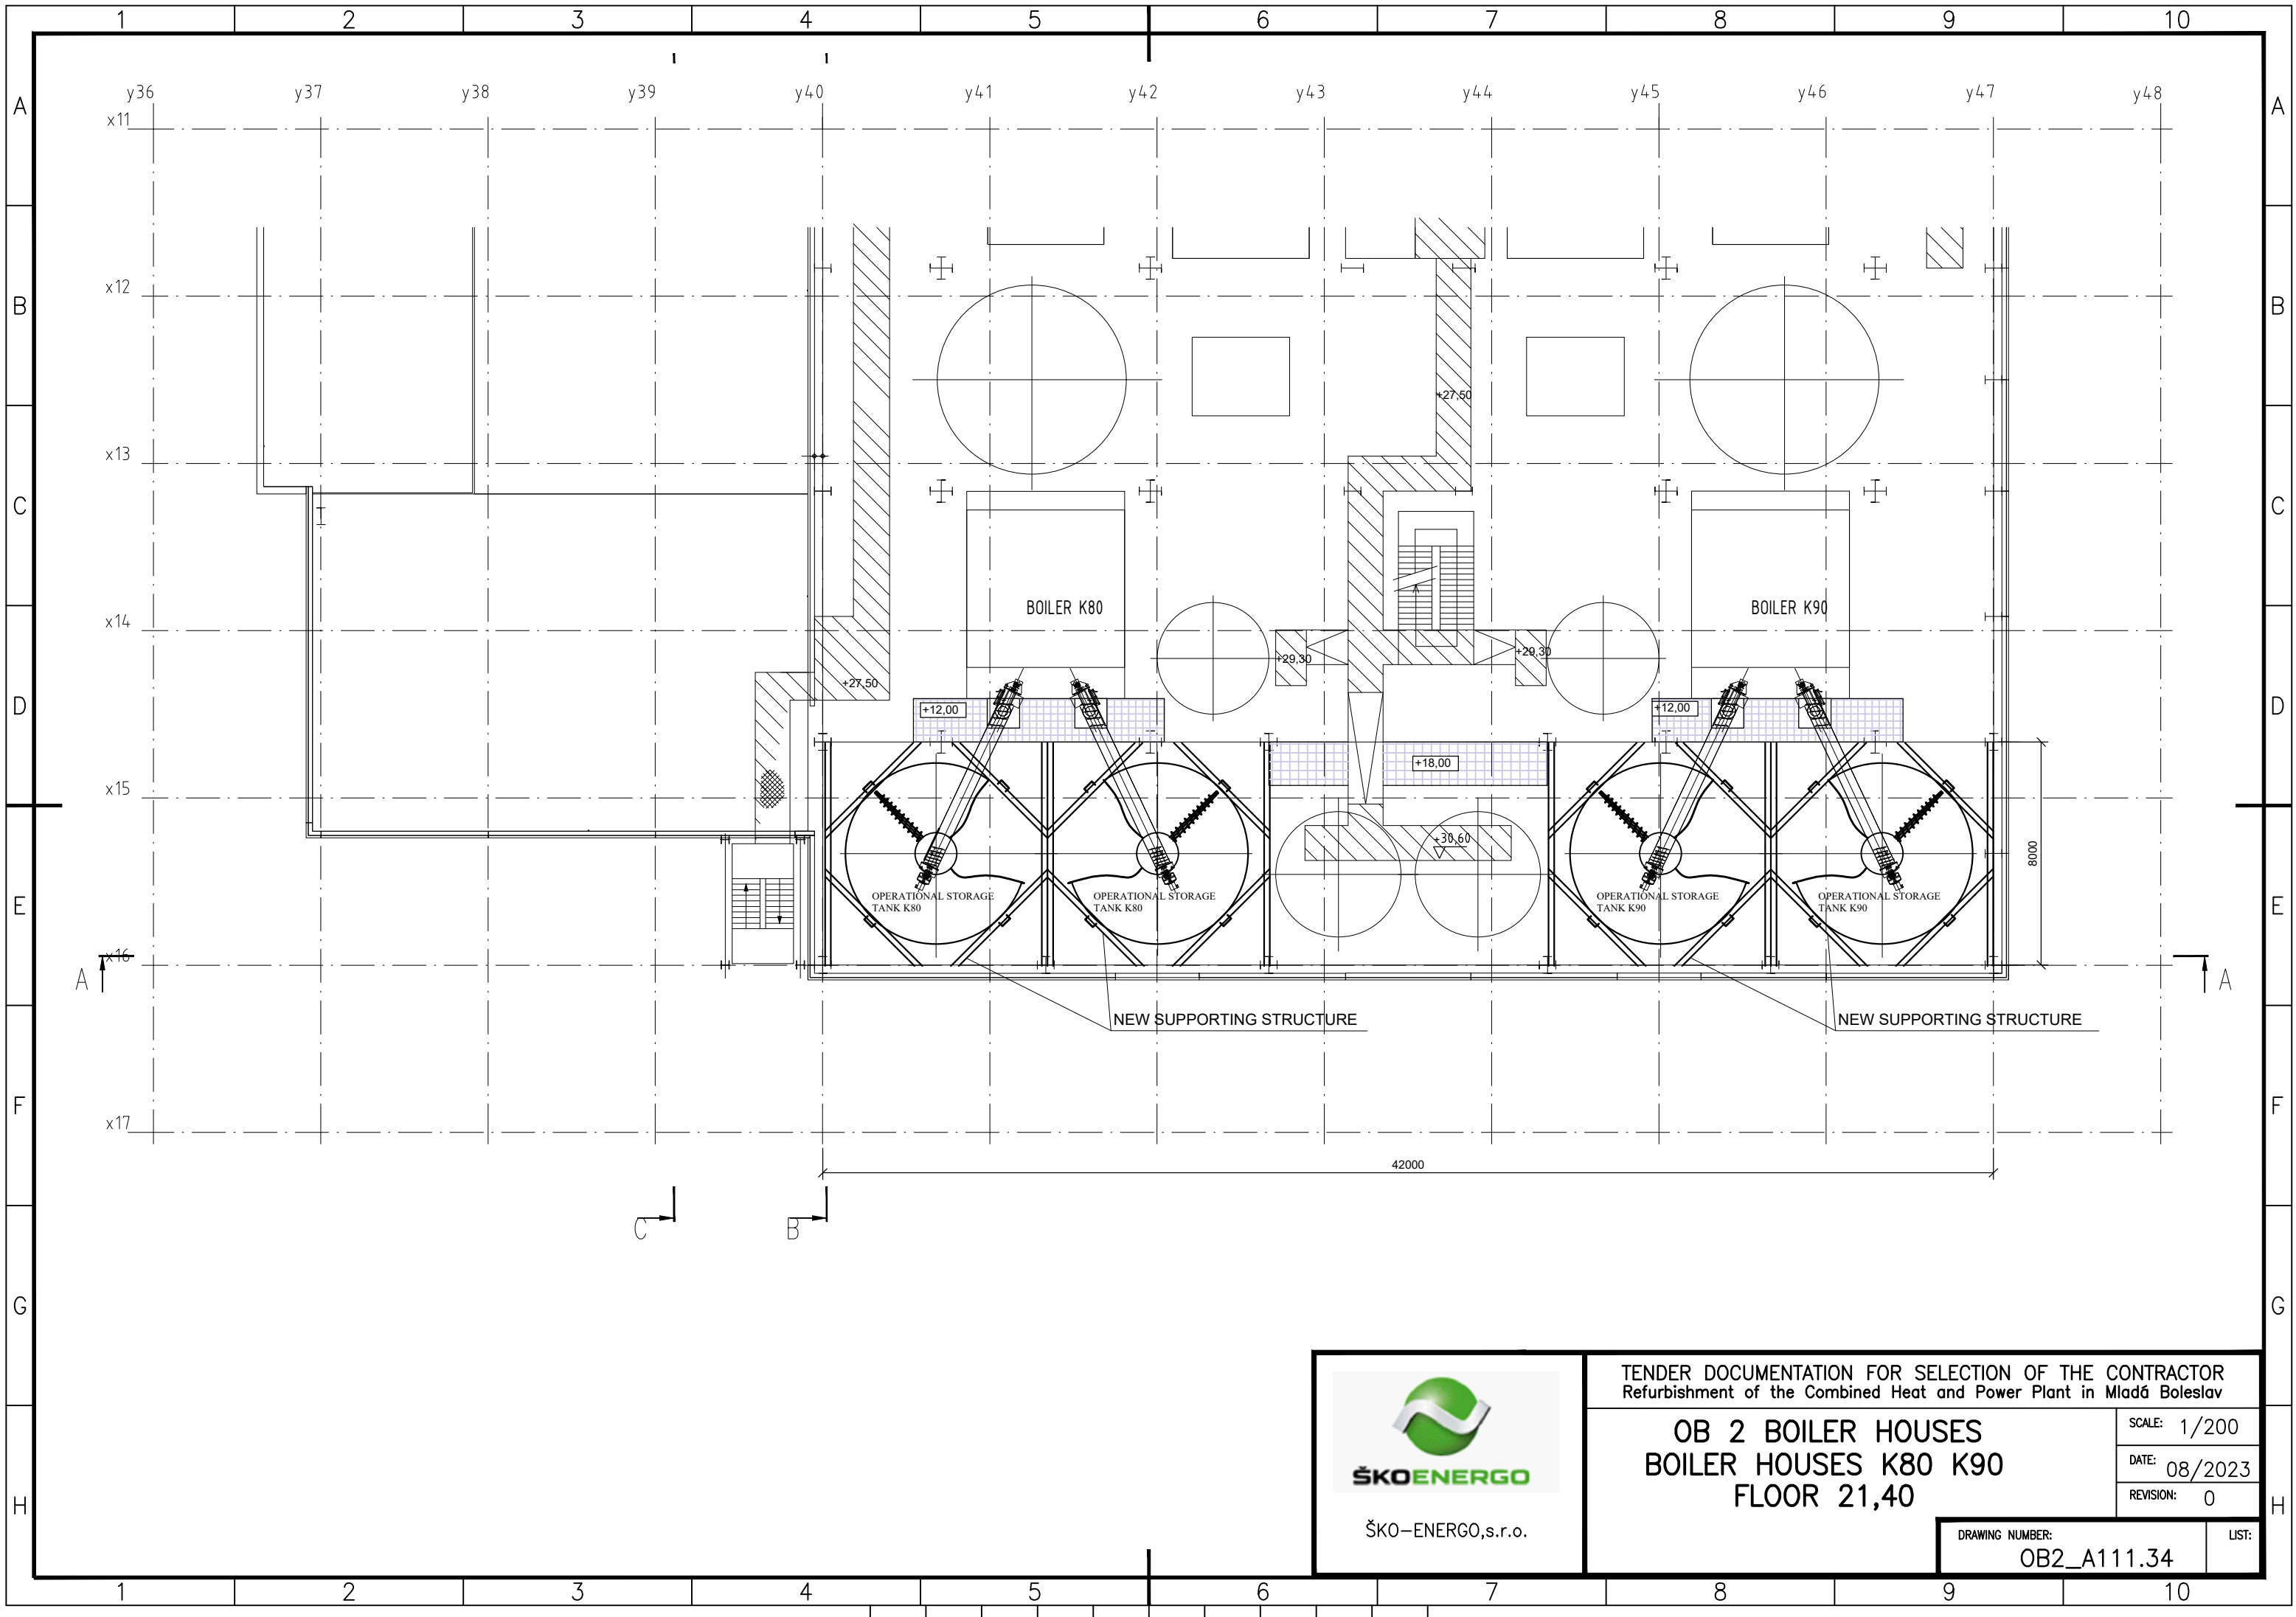



ŠKO-ENERGO,s.r.o.

TENDER DOCUMENTATION FOR SELECTION OF THE CONTRACTOR
Refurbishment of the Combined Heat and Power Plant in Mladá Boleslav

OB 2 BOILER HOUSES
BOILER HOUSES K80 K90
FLOOR 21,40

SCALE: 1/200

DATE: 08/2023

REVISION: 0

DRAWING NUMBER:
OB2_A111.34

LIST: