


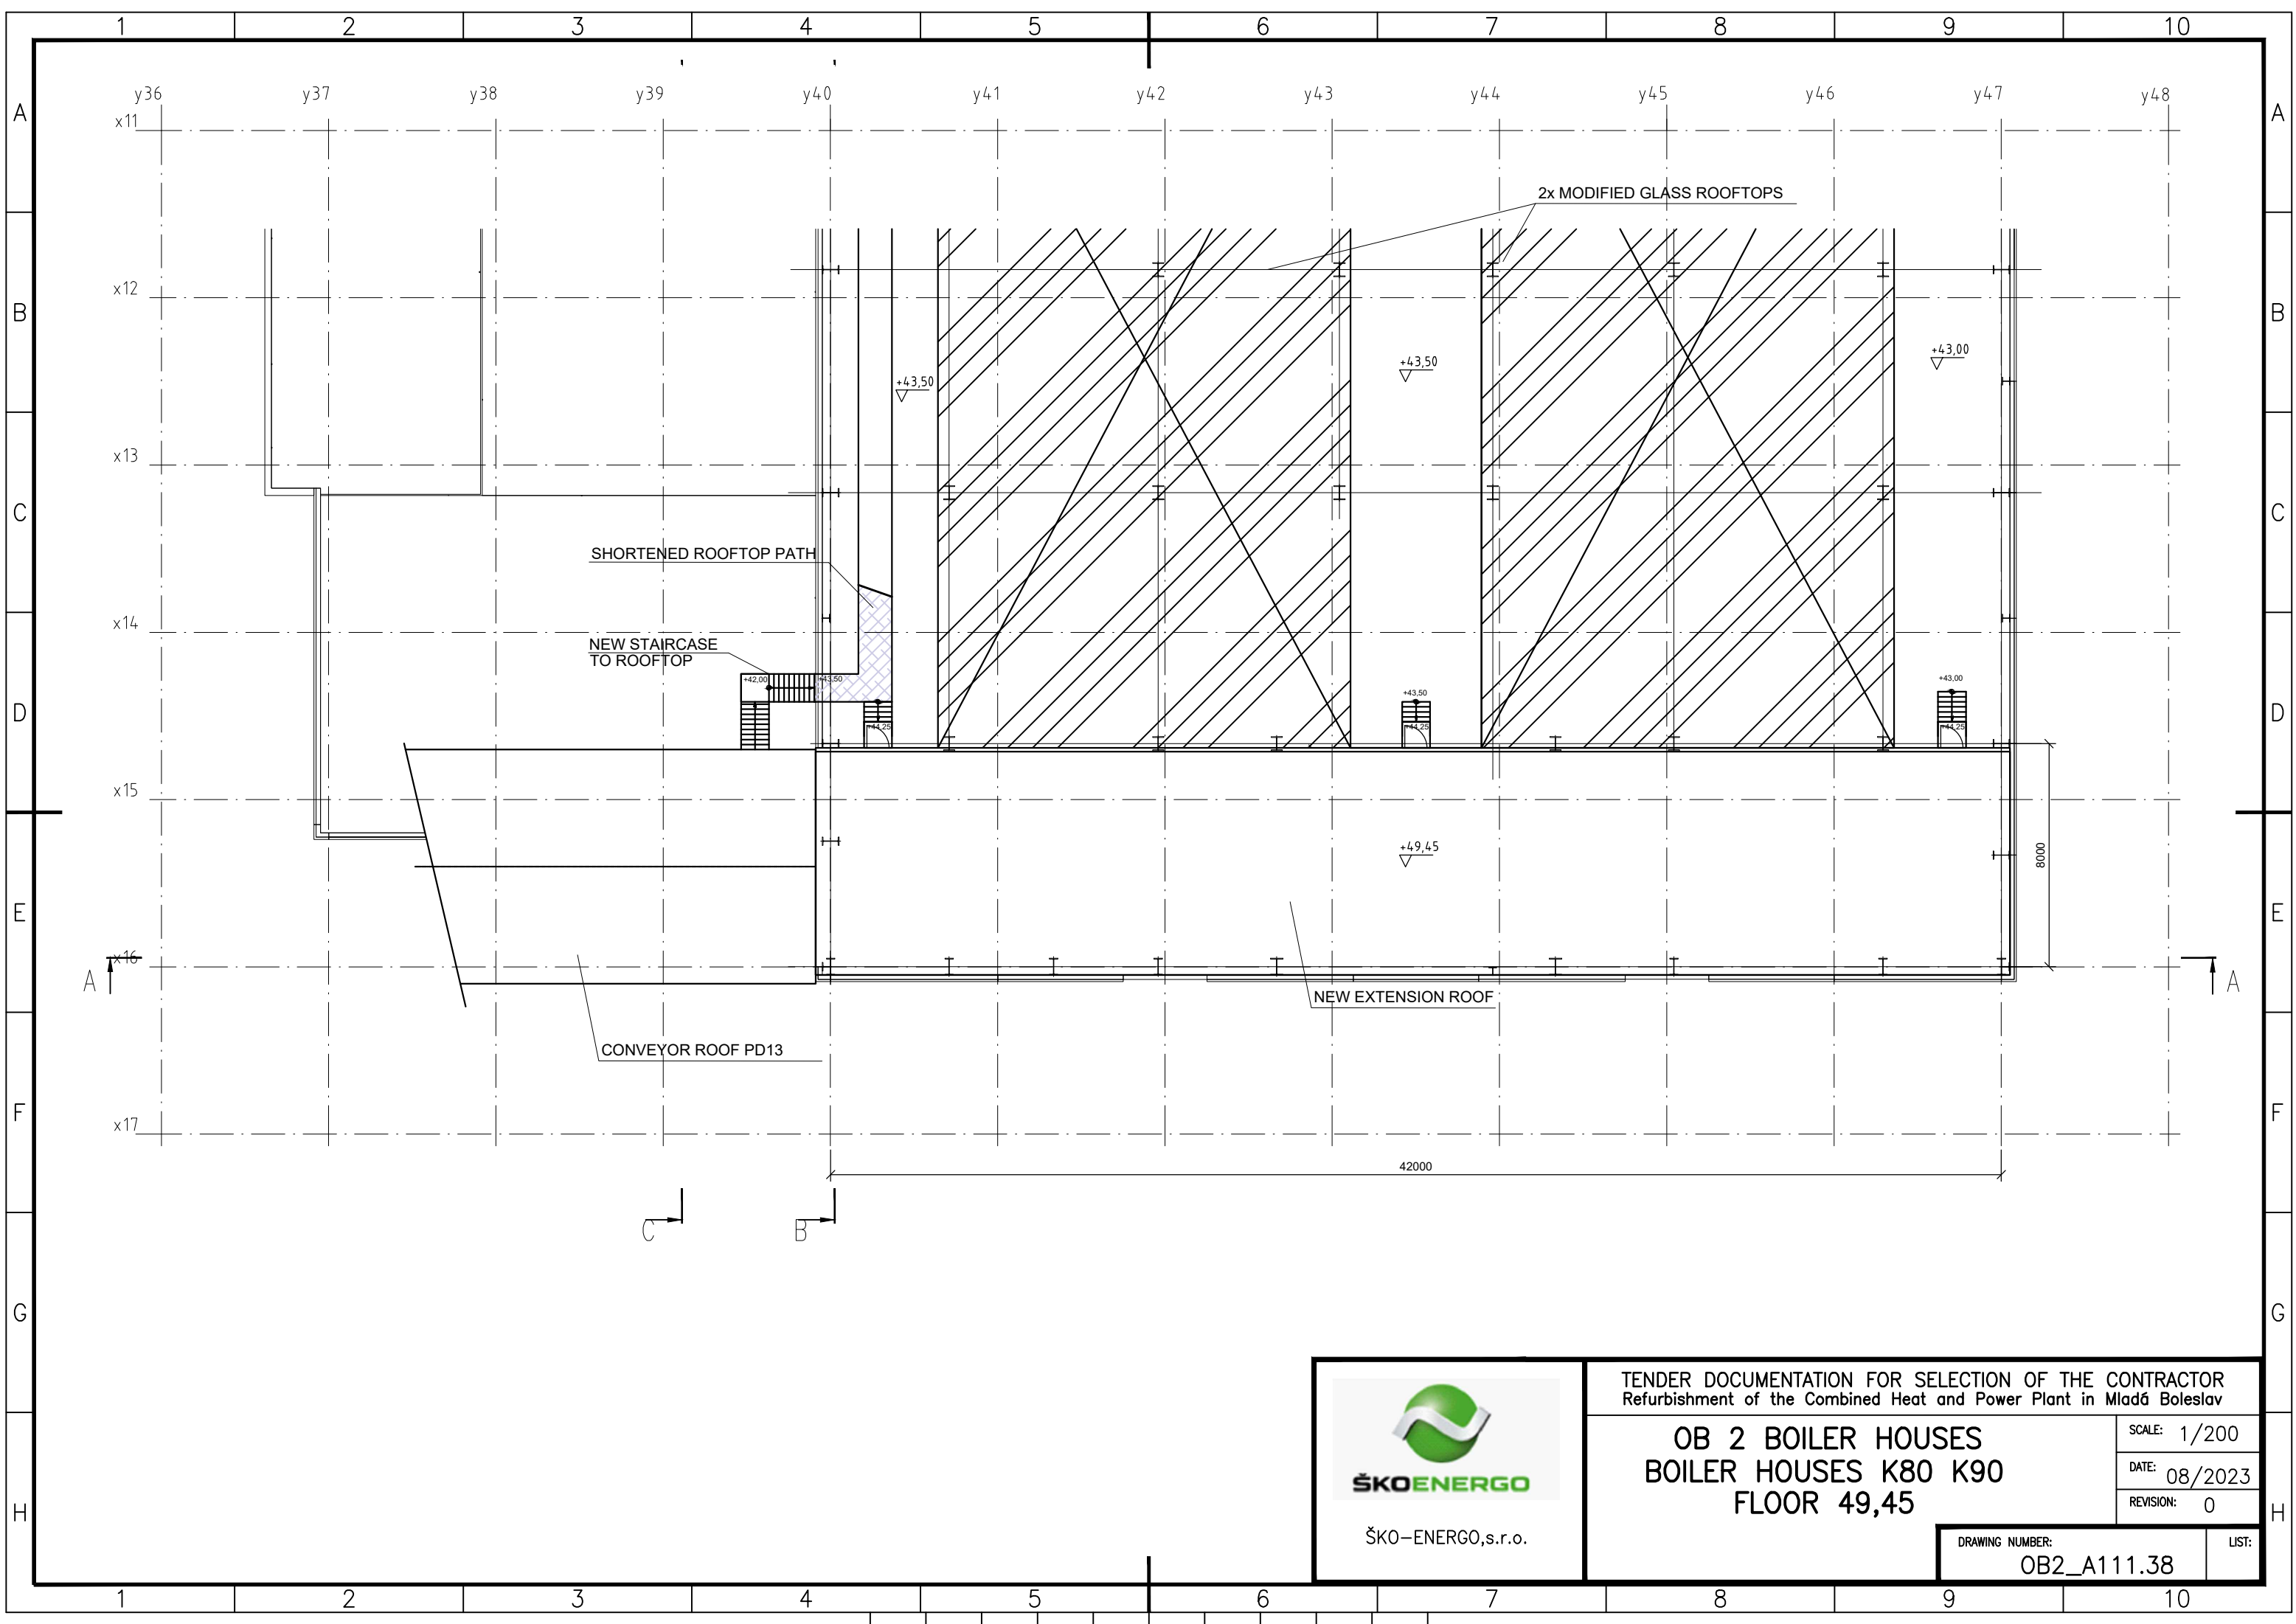

ŠKO-ENERGO,s.r.o.

TENDER DOCUMENTATION FOR SELECTION OF THE CONTRACTOR
Refurbishment of the Combined Heat and Power Plant in Mladá Boleslav

OB 2 BOILER HOUSES
BOILER HOUSES K80 K90
FLOOR 49,45

SCALE:	1/200
DATE:	08/2023
REVISION:	0

DRAWING NUMBER:	OB2_A111.38
-----------------	-------------

LIST: