


SECTION A-A

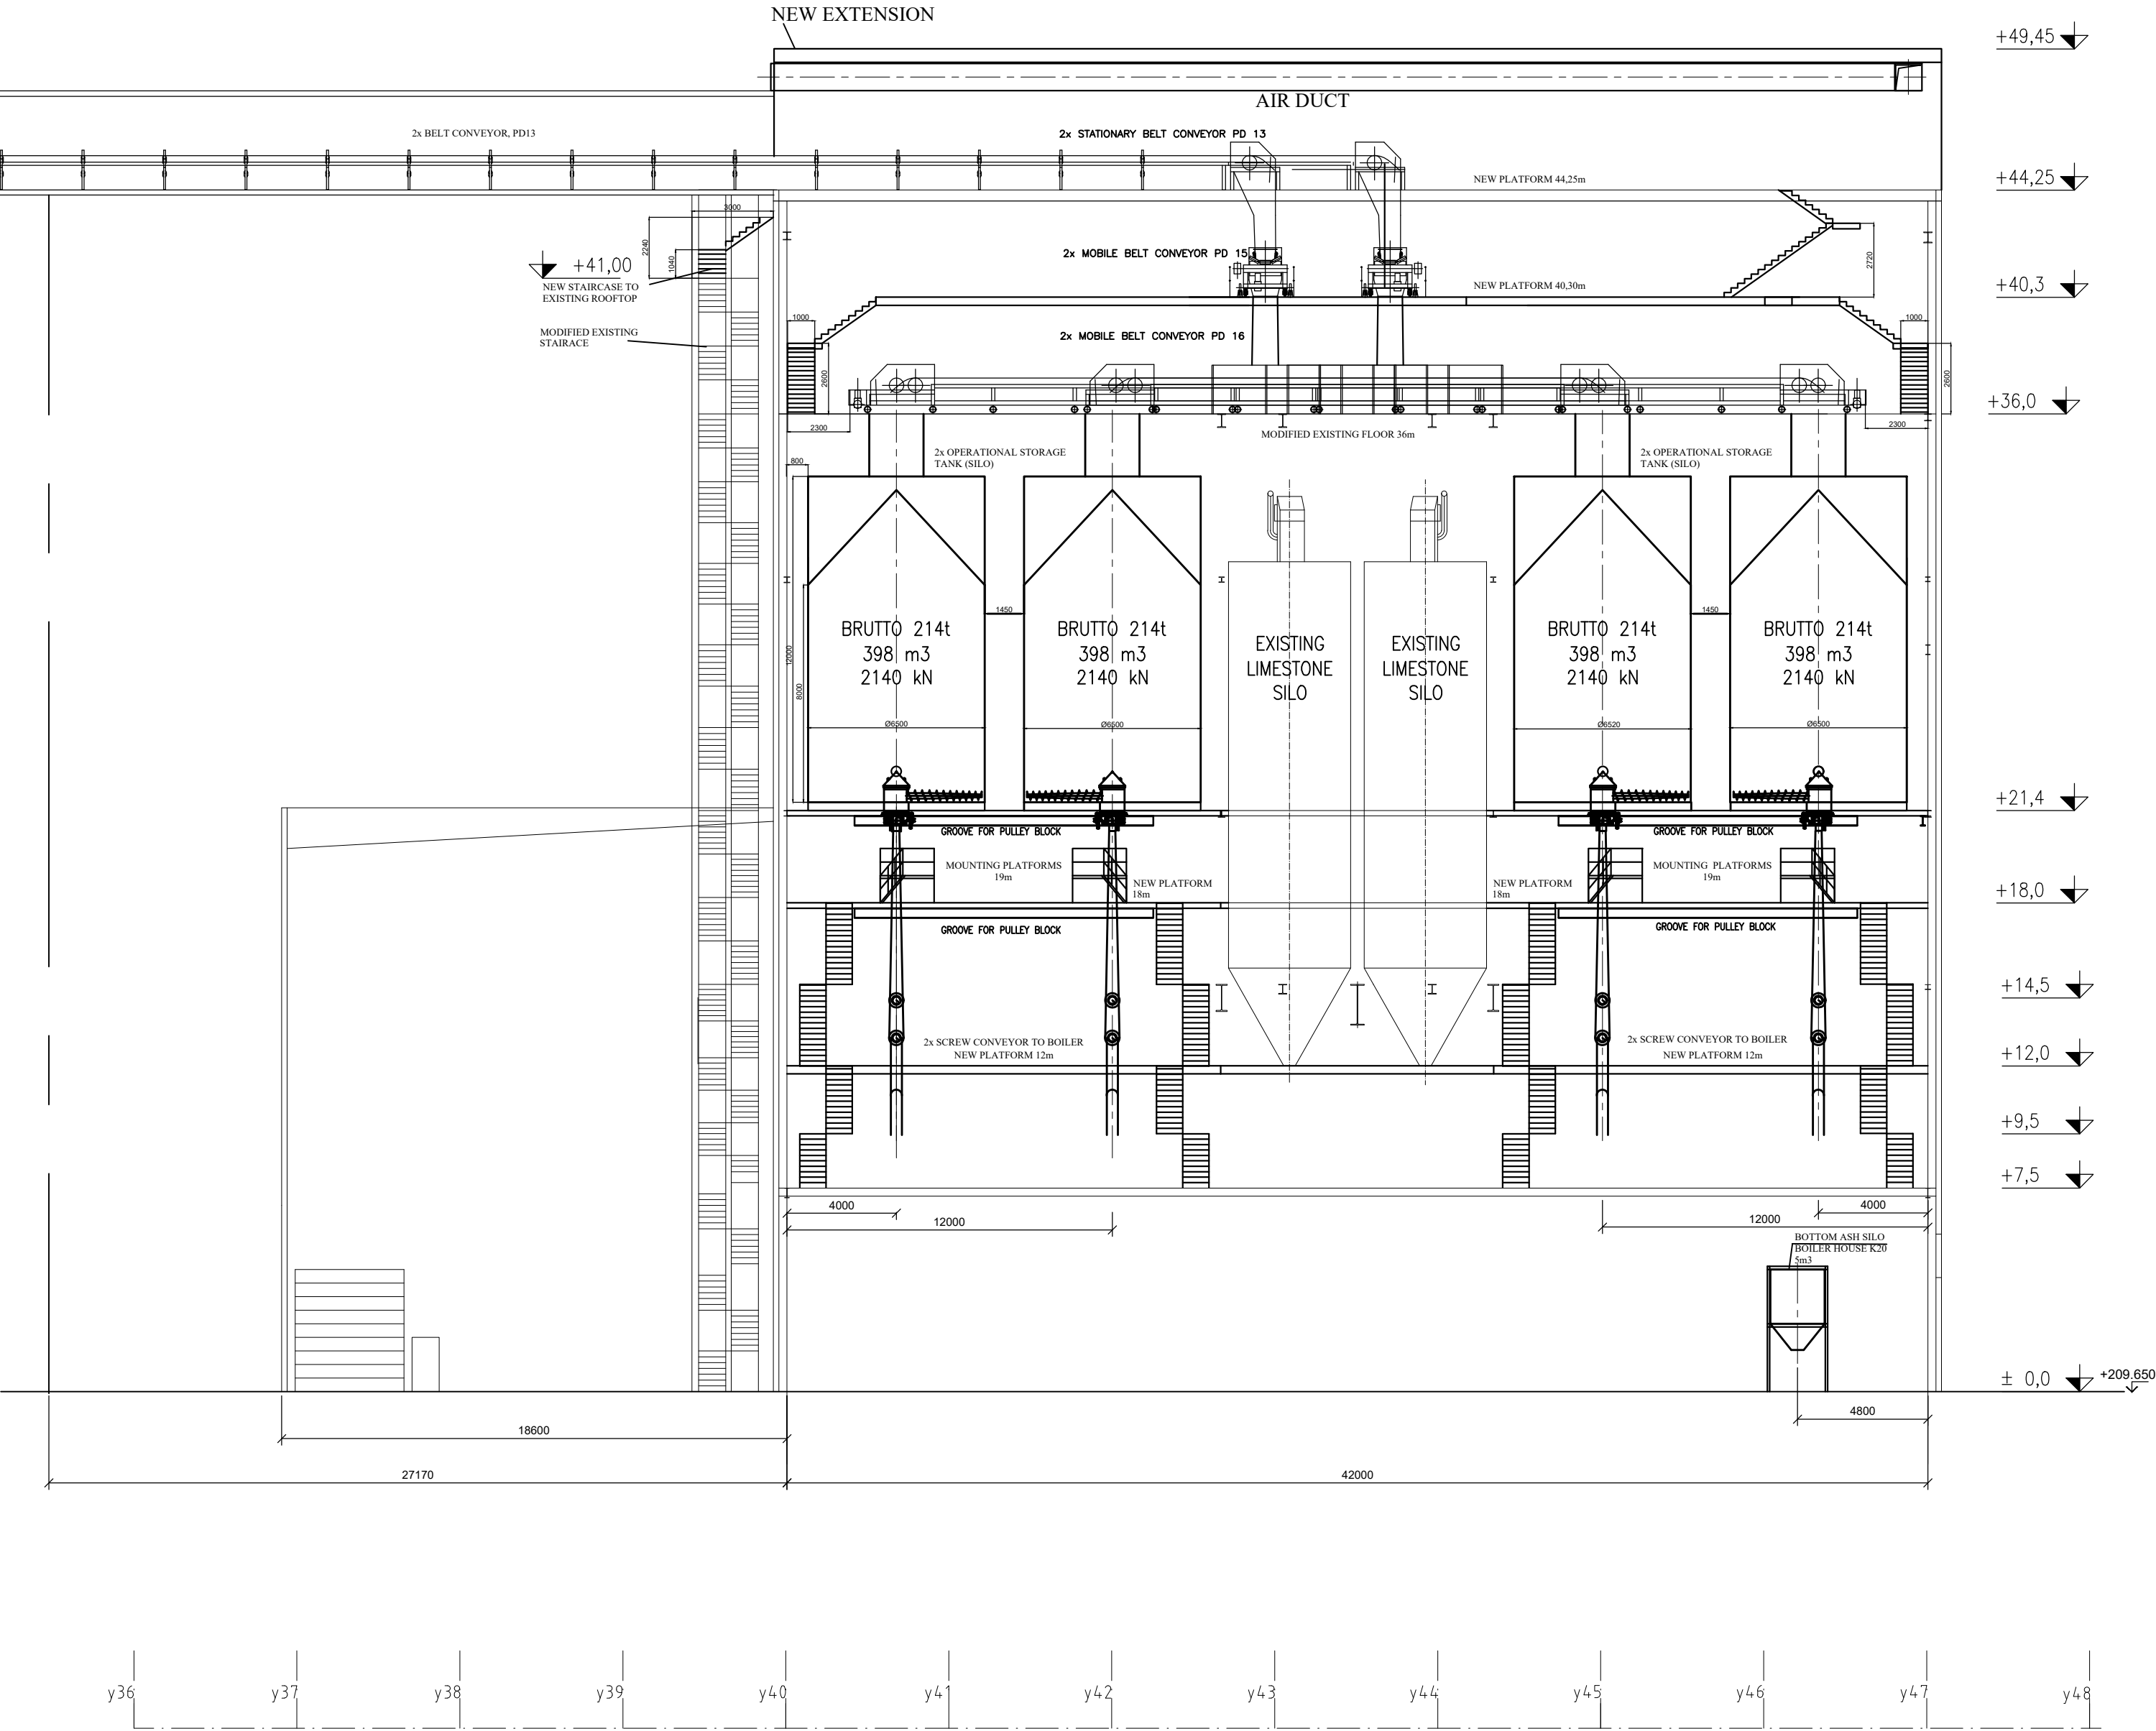

±0,00=209,65



TENDER DOCUMENTATION FOR SELECTION OF THE CONTRACTOR
Refurbishment of the Combined Heat and Power Plant in Mladá Boleslav

OB 2 BOILER HOUSES
BOILER HOUSES K80 K90
SECTION A-A

SCALE: 1/200
DATE: 08/2023
REVISION: 0

DRAWING NUMBER: OB2_A111.39
LIST: