



SECTION B-B

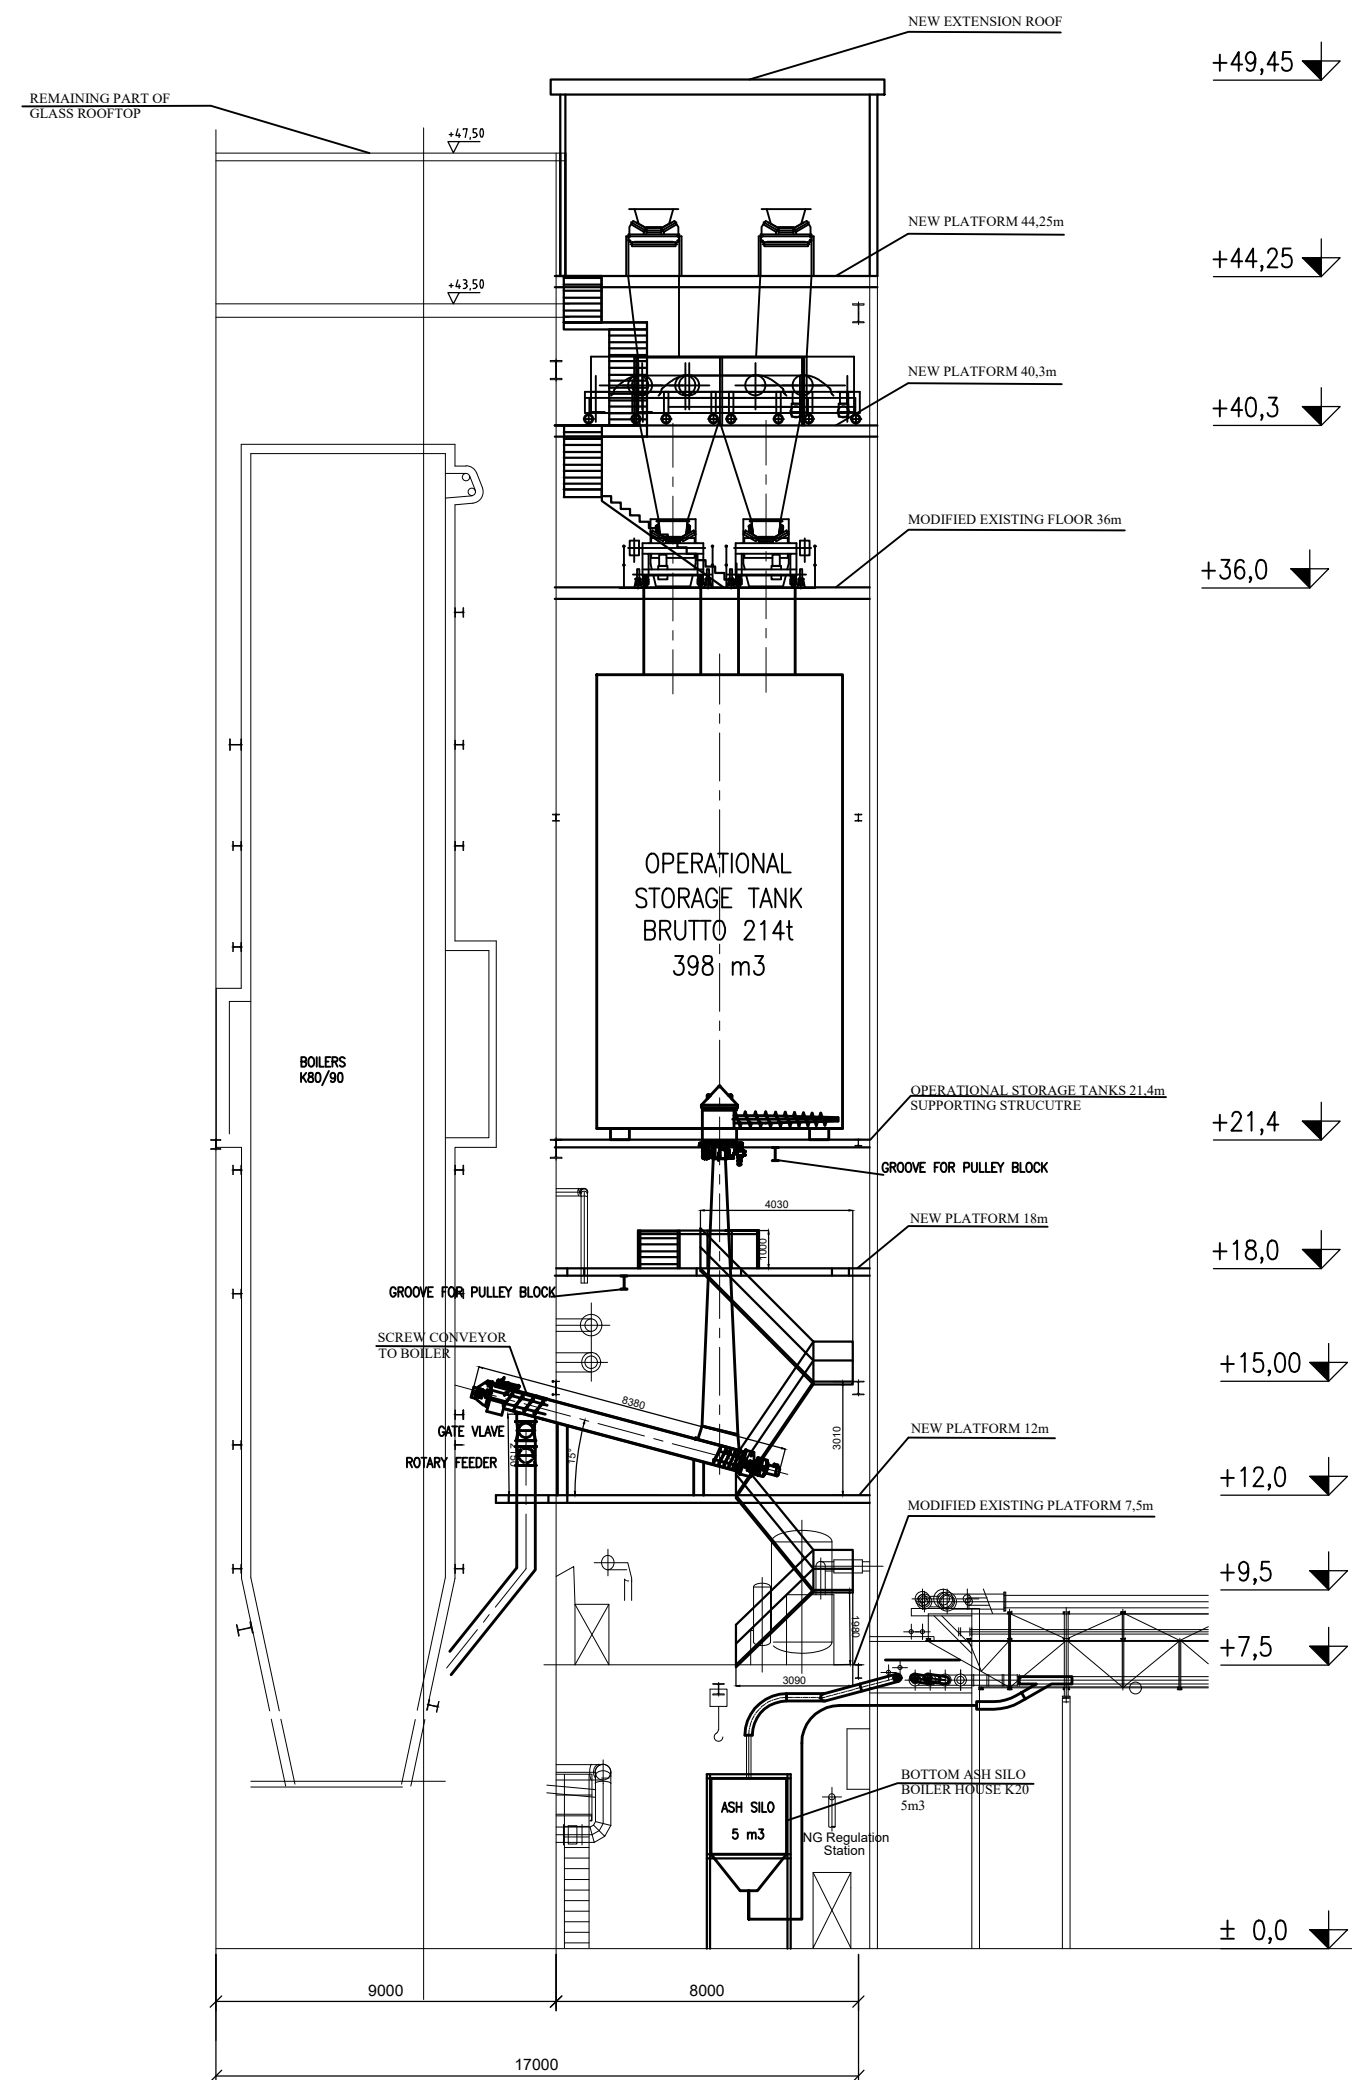

SECTION C-C

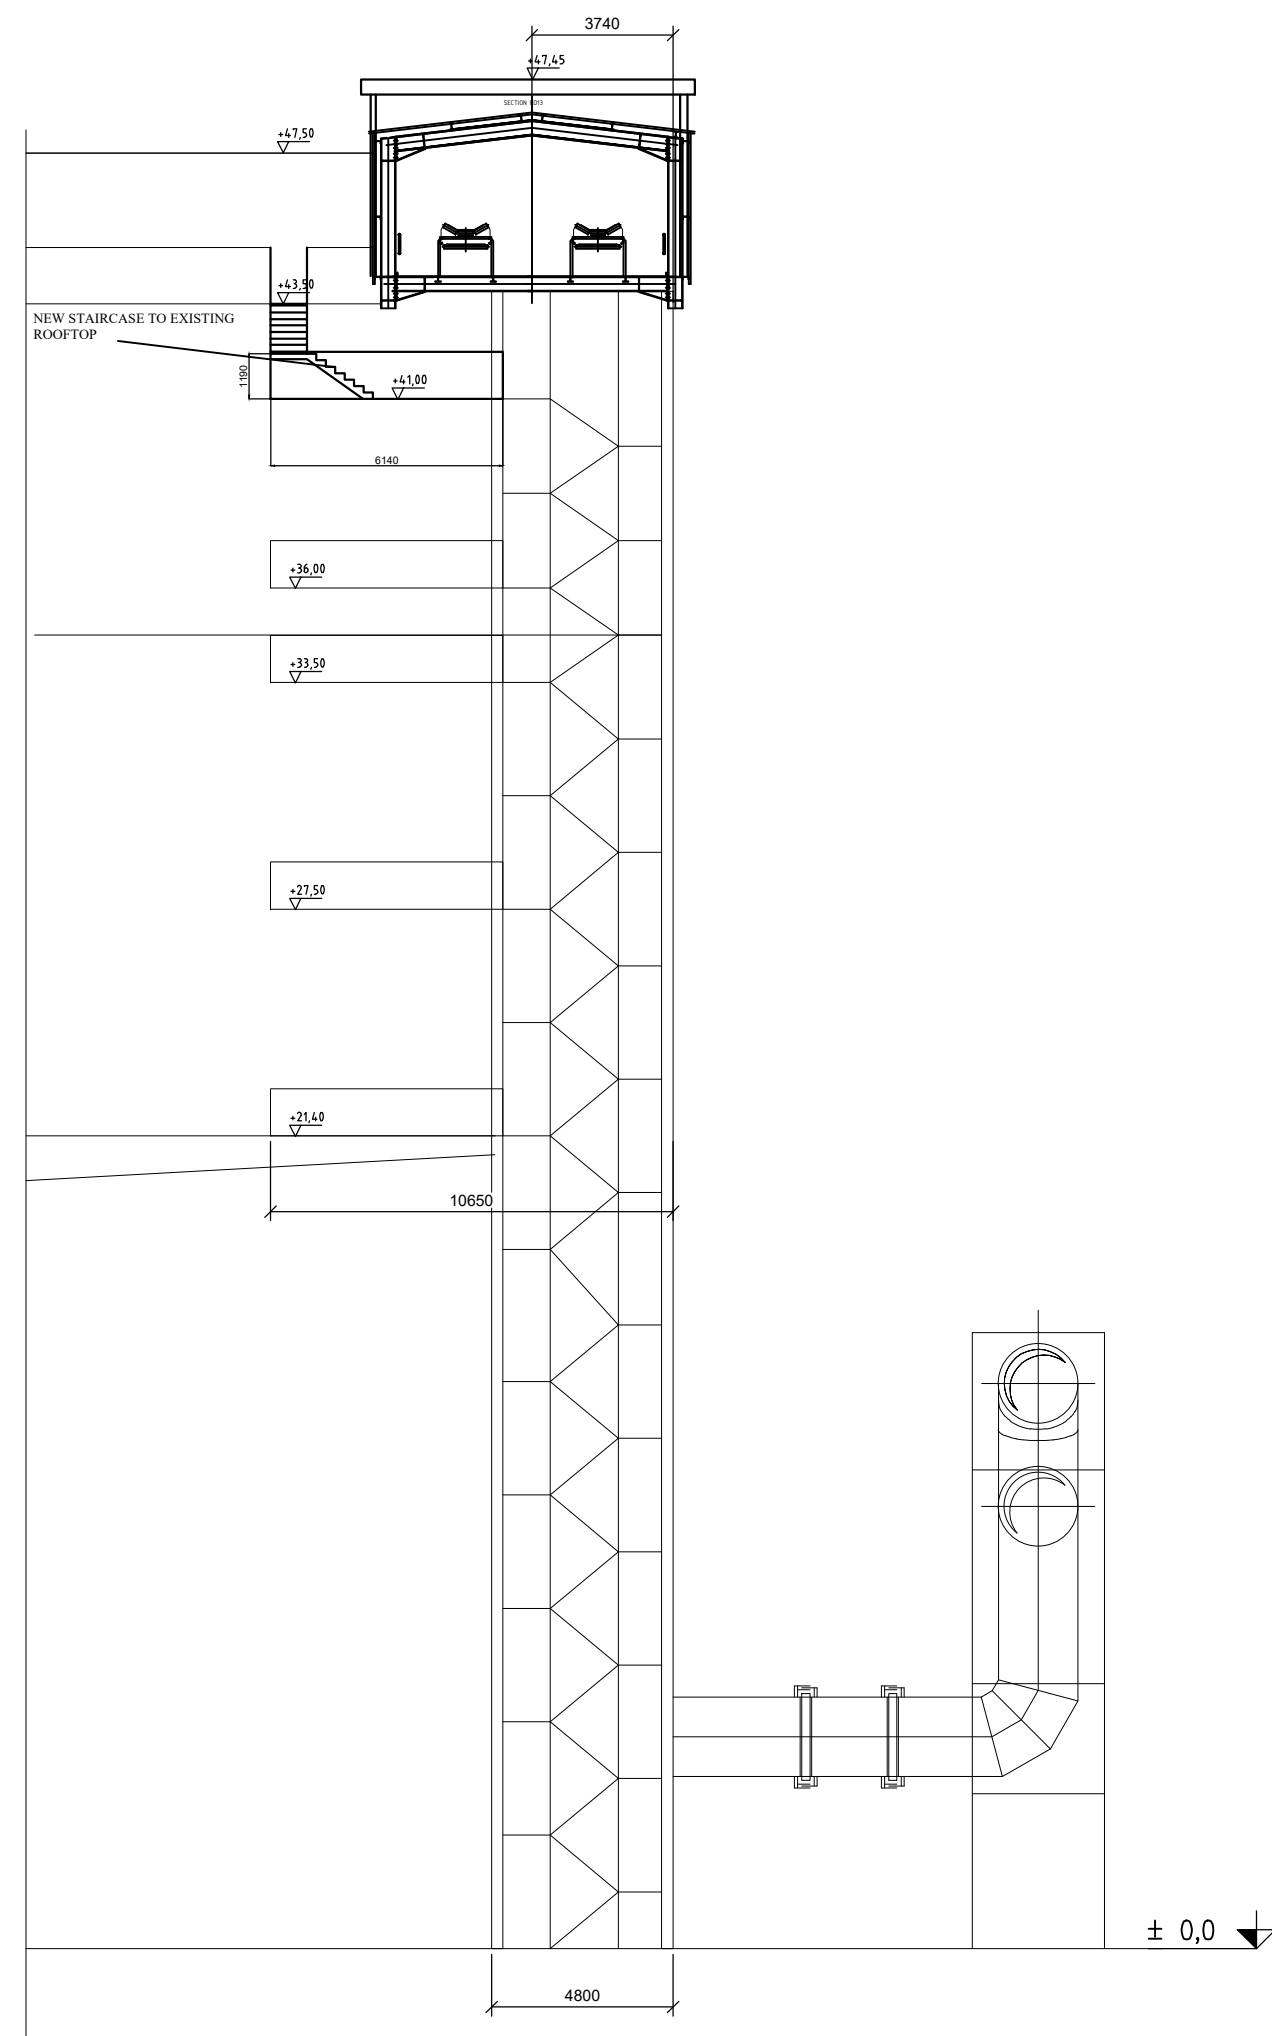

±0,00=209,65



ŠKO-ENERGO, s.r.o.

TENDER DOCUMENTATION FOR SELECTION OF THE CONTRACTOR
Refurbishment of the Combined Heat and Power Plant in Mladá BoleslavOB 2 BOILER HOUSES
BOILER HOUSES K80 K90
SECTION B-B C-C

SCALE: 1/200

DATE: 08/2023

REVISION: 0

DRAWING NUMBER:

OB2_A111.40

LIST: