

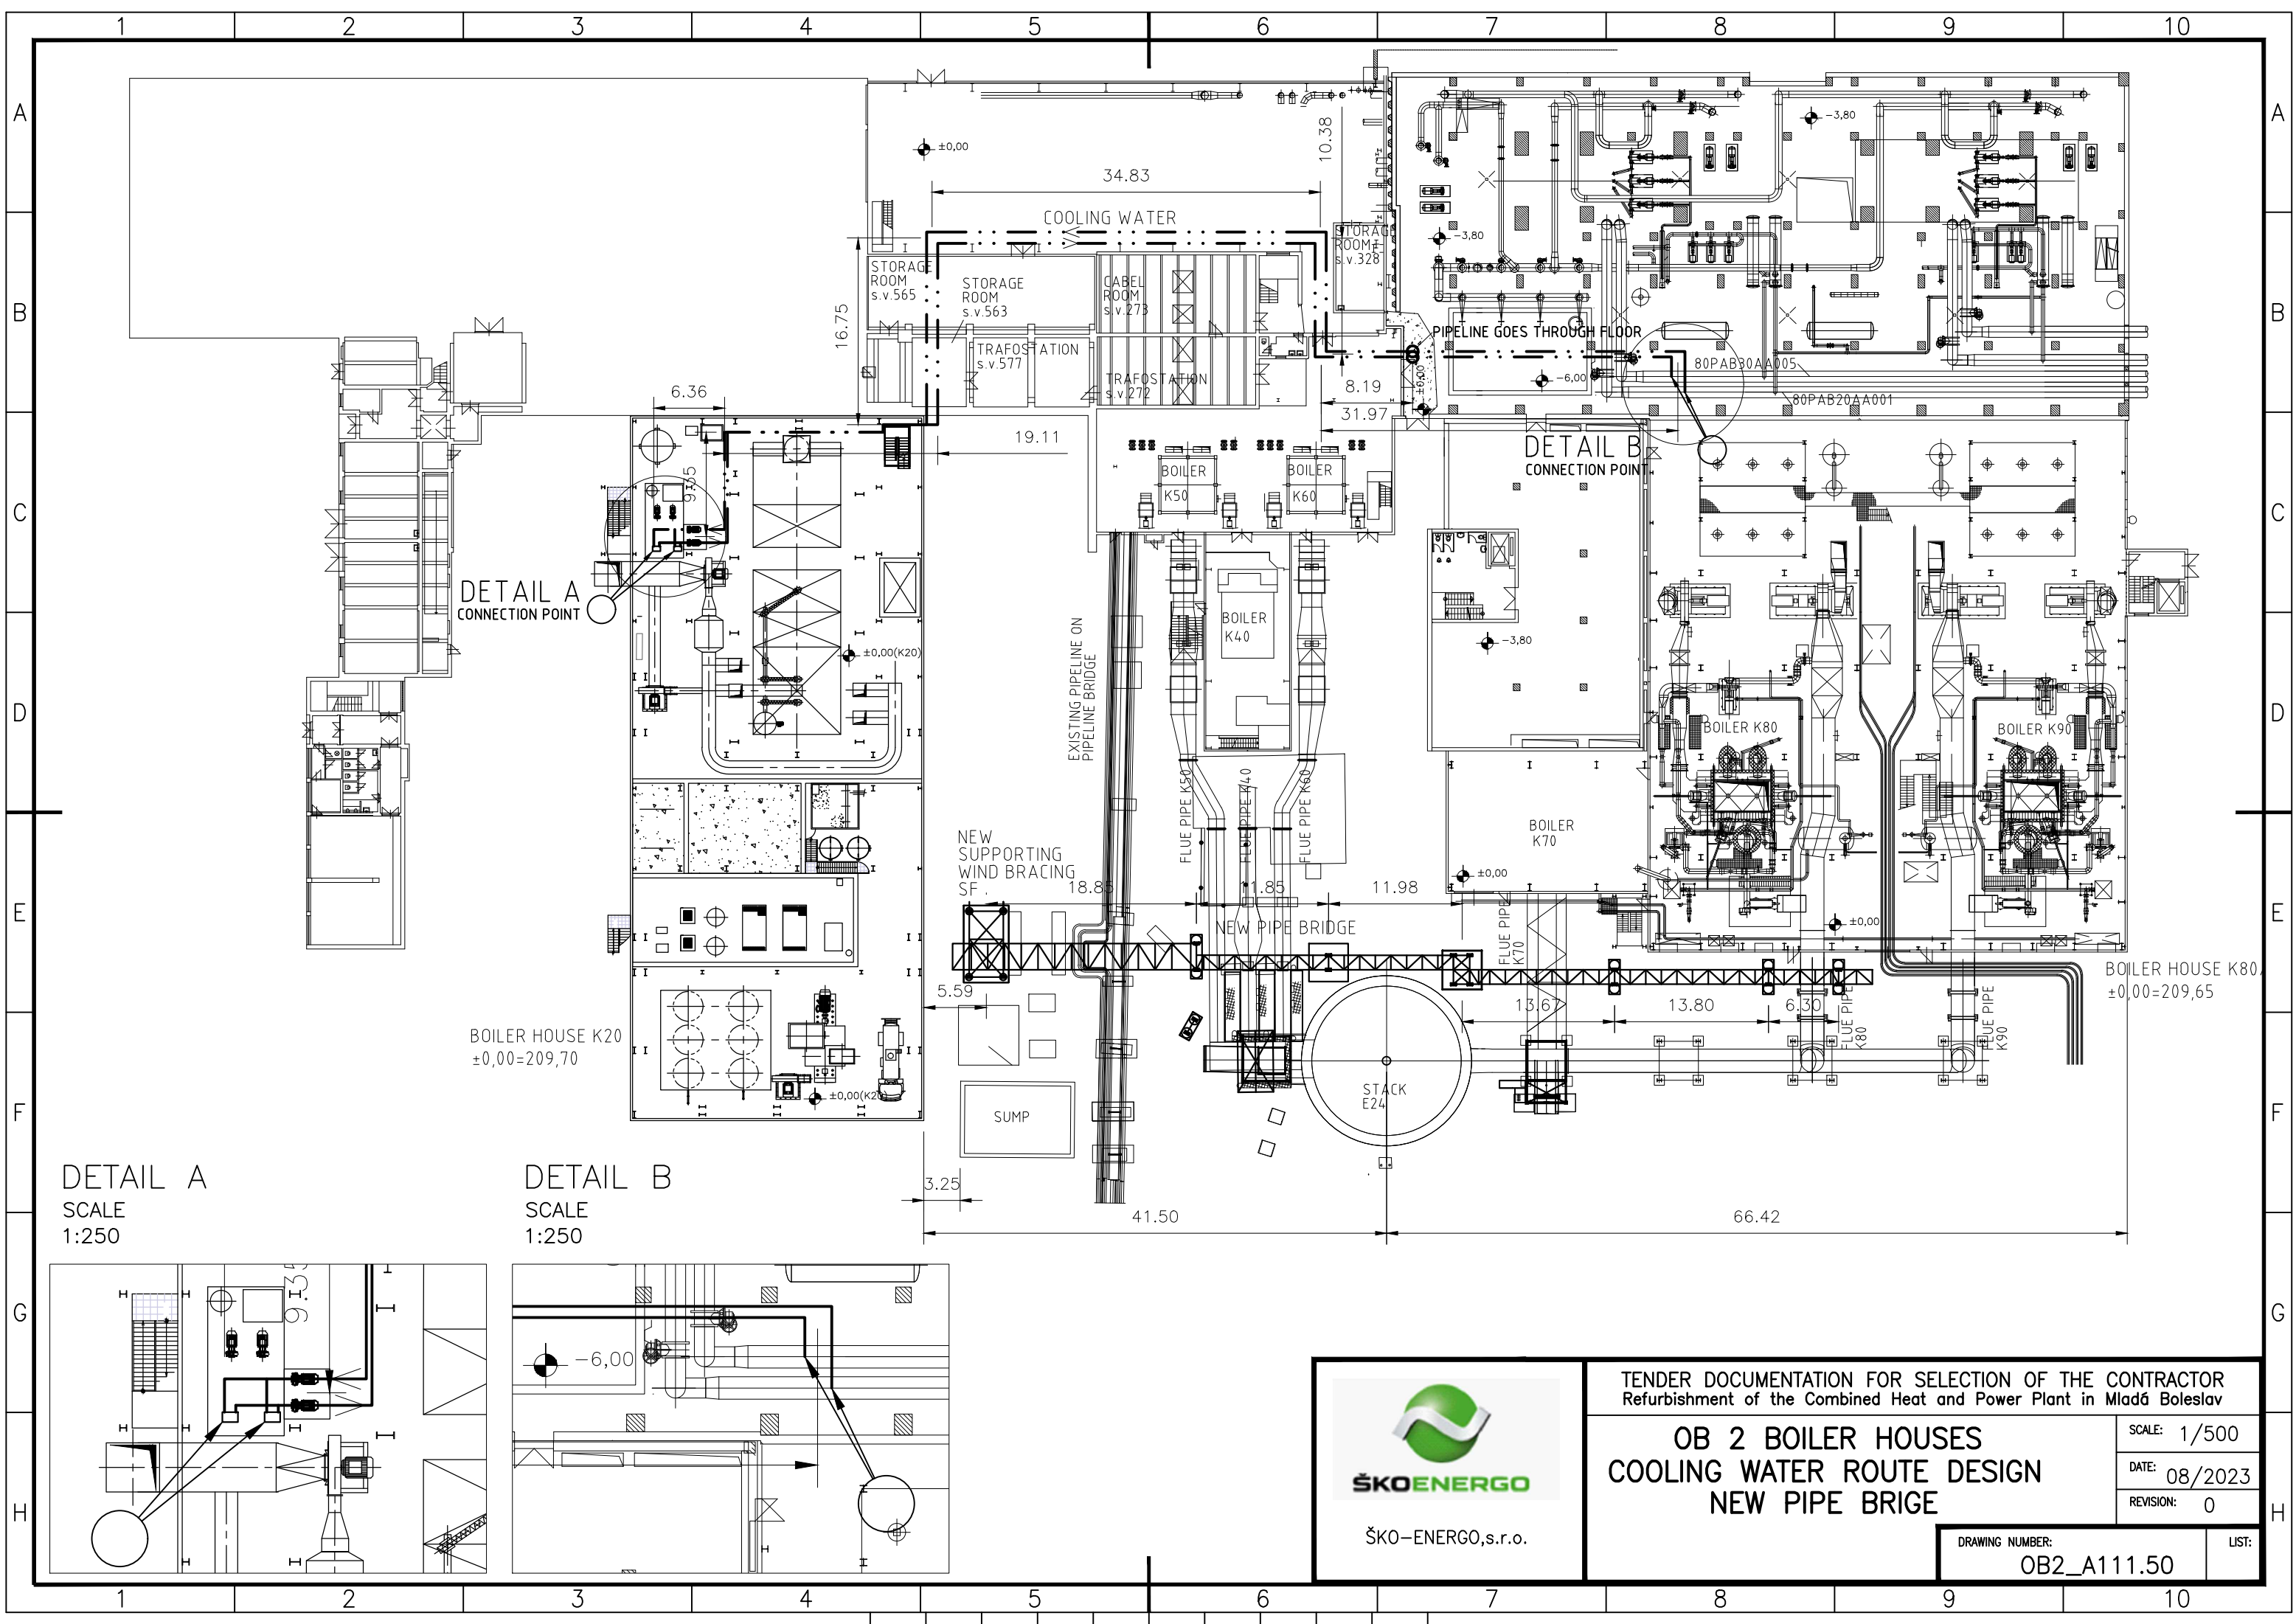
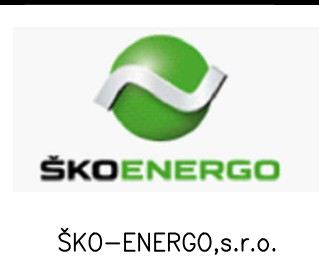


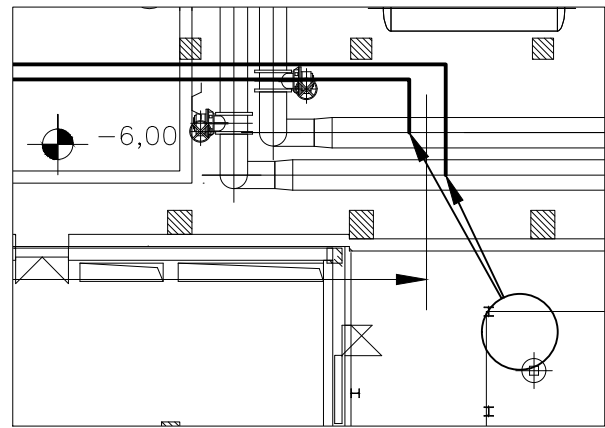

DETAIL A  
SCALE  
1:250

DETAIL B  
SCALE  
1:250

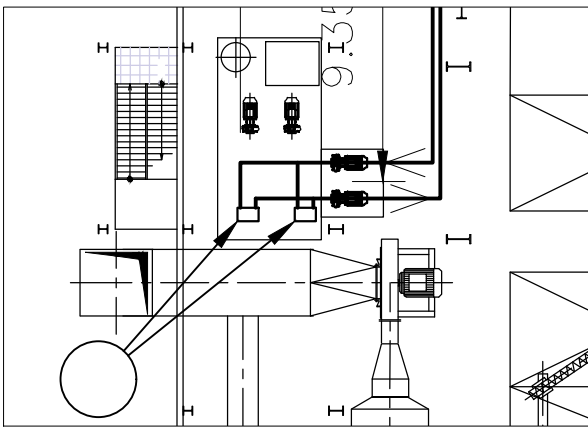

|                                                                                                                              |               |
|------------------------------------------------------------------------------------------------------------------------------|---------------|
| TENDER DOCUMENTATION FOR SELECTION OF THE CONTRACTOR<br>Refurbishment of the Combined Heat and Power Plant in Mladá Boleslav |               |
| OB 2 BOILER HOUSES<br>COOLING WATER ROUTE DESIGN<br>NEW PIPE BRIDGE                                                          |               |
| SCALE: 1/500                                                                                                                 | DATE: 08/2023 |
| REVISION: 0                                                                                                                  |               |
| DRAWING NUMBER:<br>OB2_A111.50                                                                                               | LIST:         |