




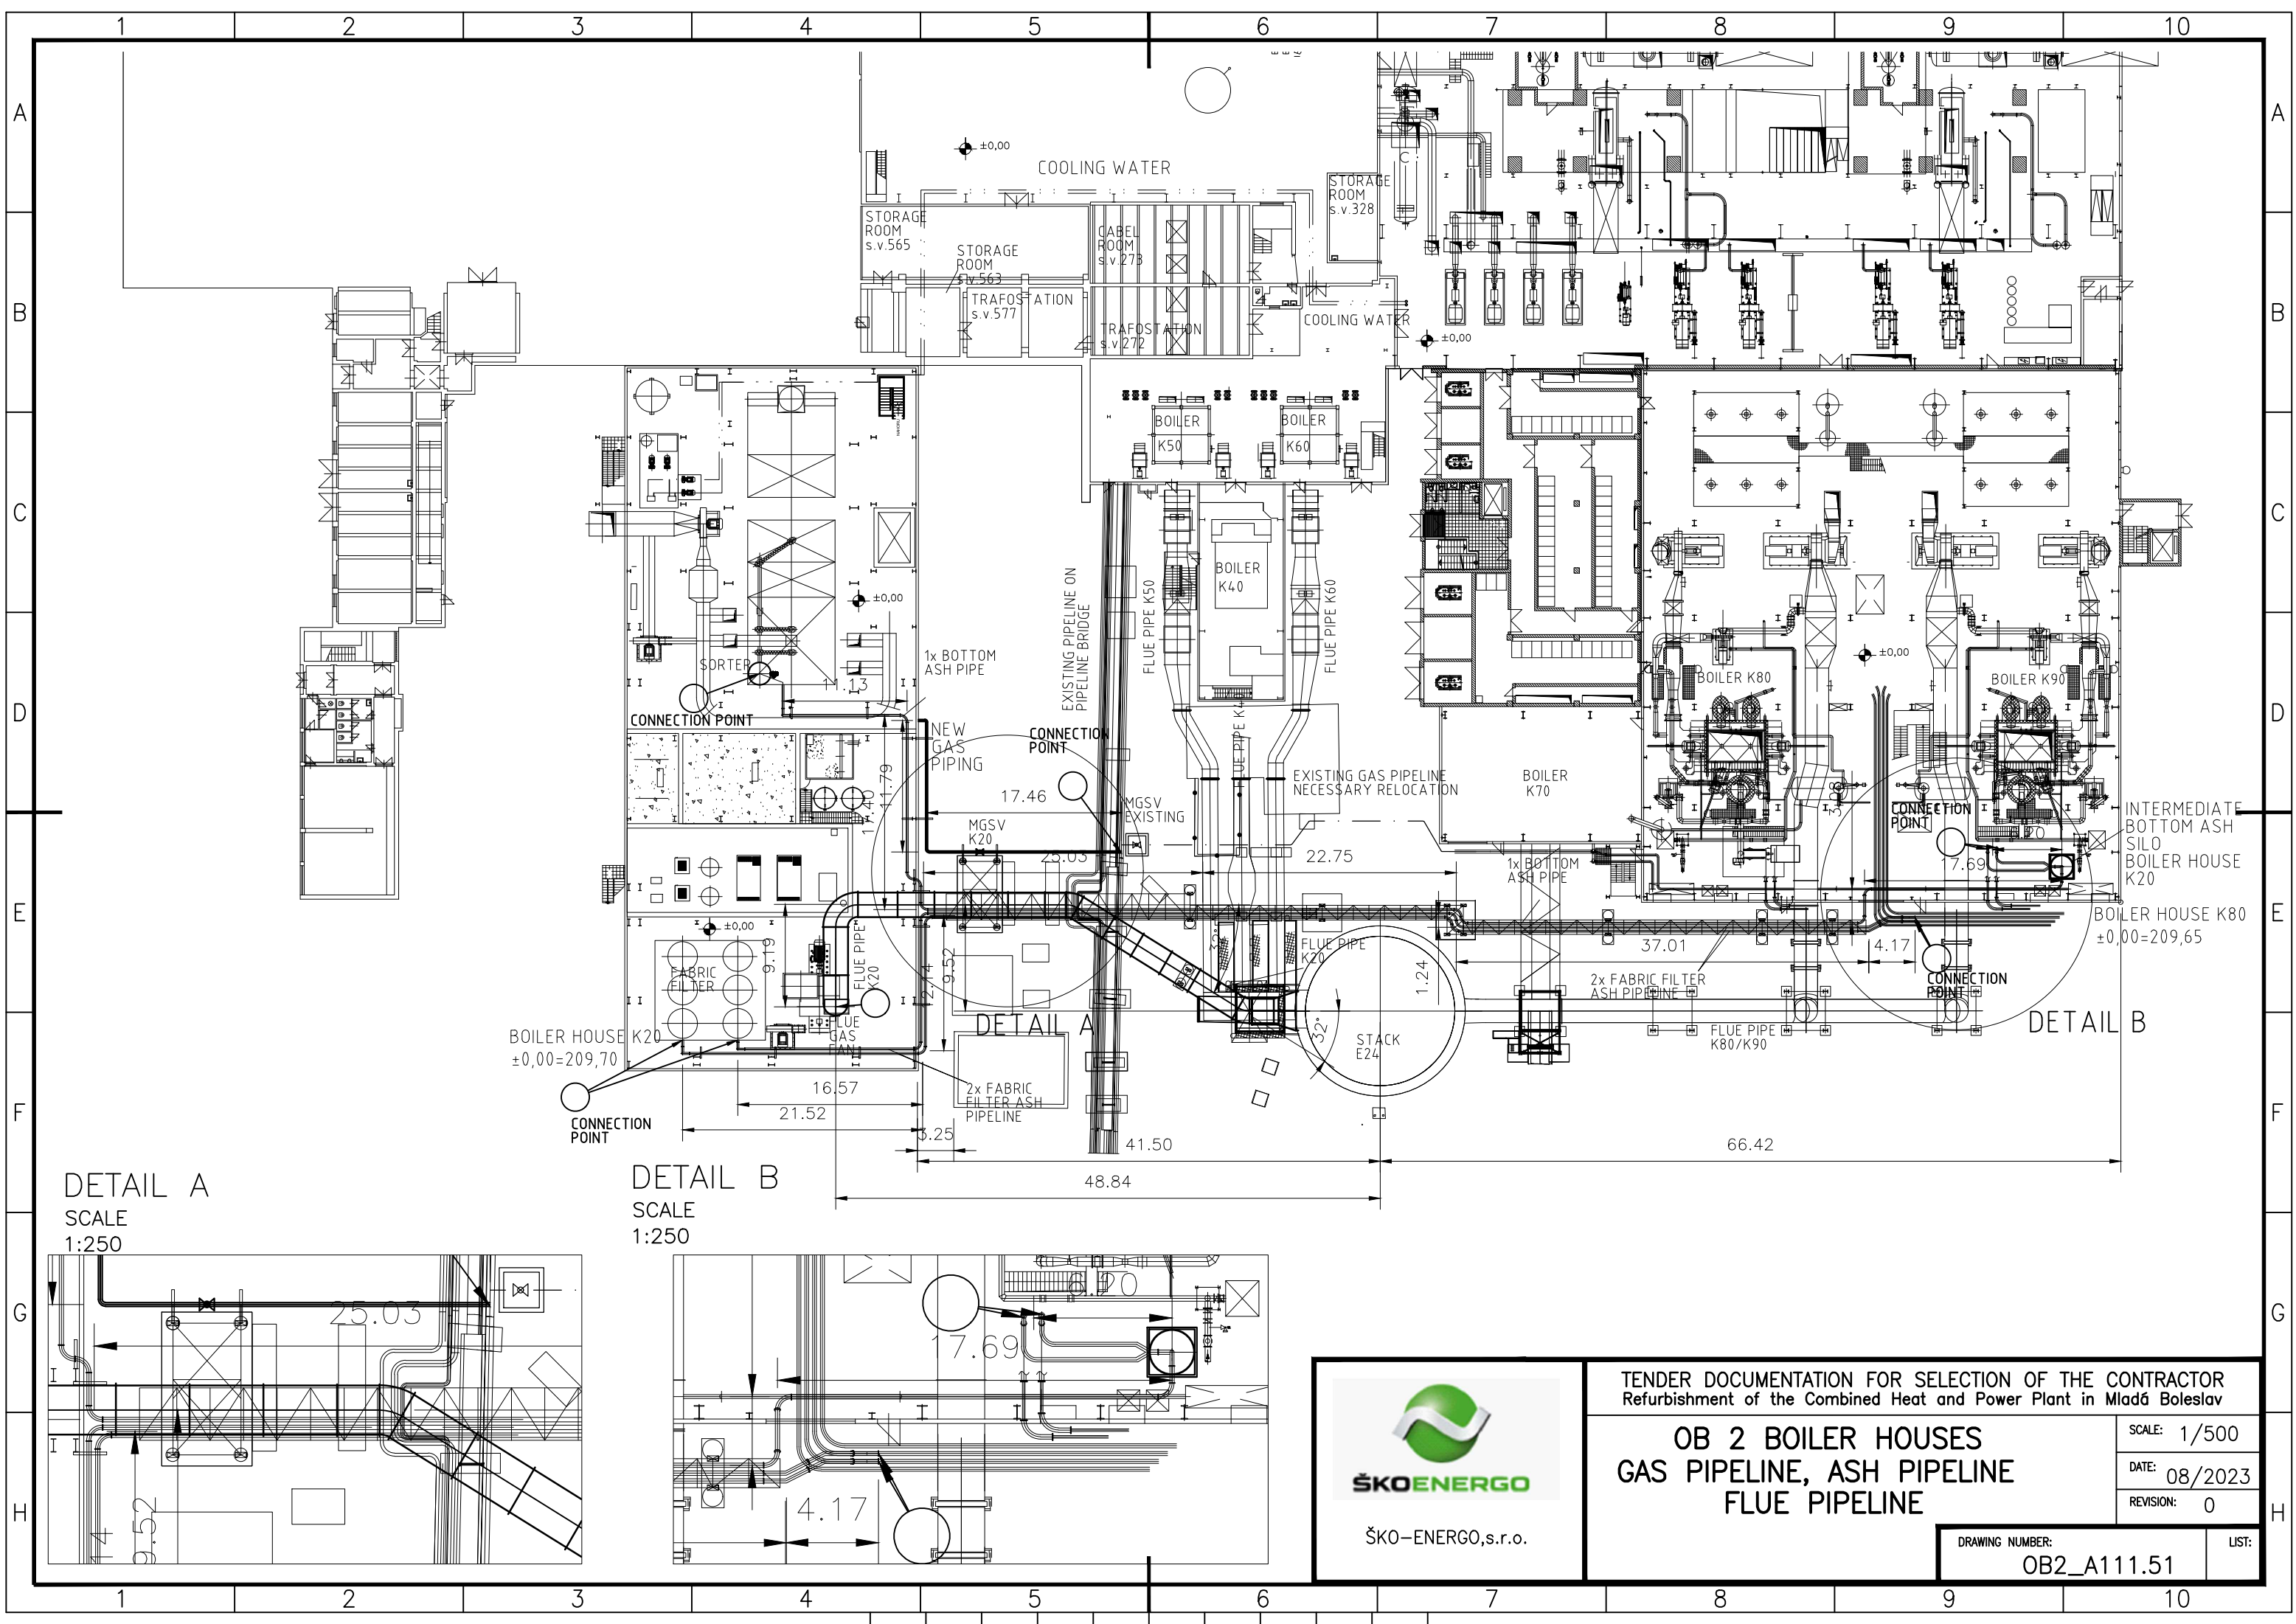

DETAIL A
SCALE
1:250

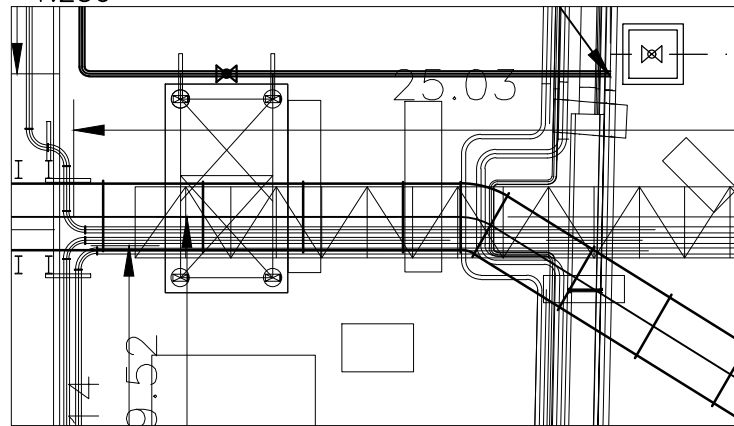

DETAIL B
SCALE
1:250

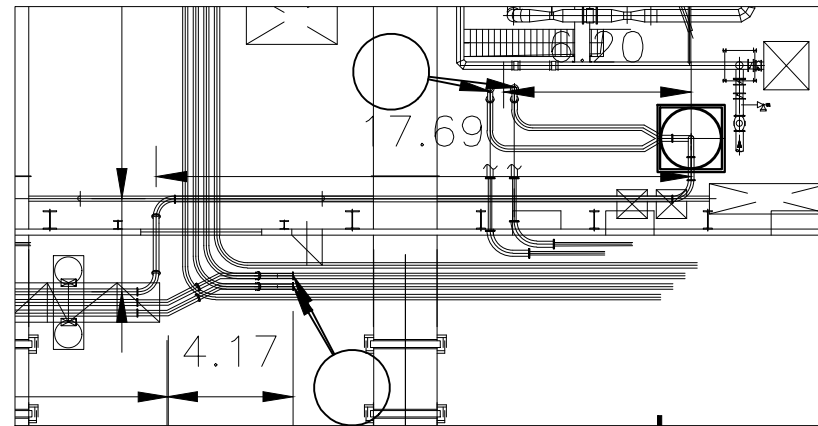

ŠKO-ENERGO, s.r.o.

TENDER DOCUMENTATION FOR SELECTION OF THE CONTRACTOR
Refurbishment of the Combined Heat and Power Plant in Mladá Boleslav

OB 2 BOILER HOUSES
GAS PIPELINE, ASH PIPELINE
FLUE PIPELINE

SCALE: 1/500

DATE: 08/2023

REVISION: 0

DRAWING NUMBER:
OB2_A111.51

LIST: