


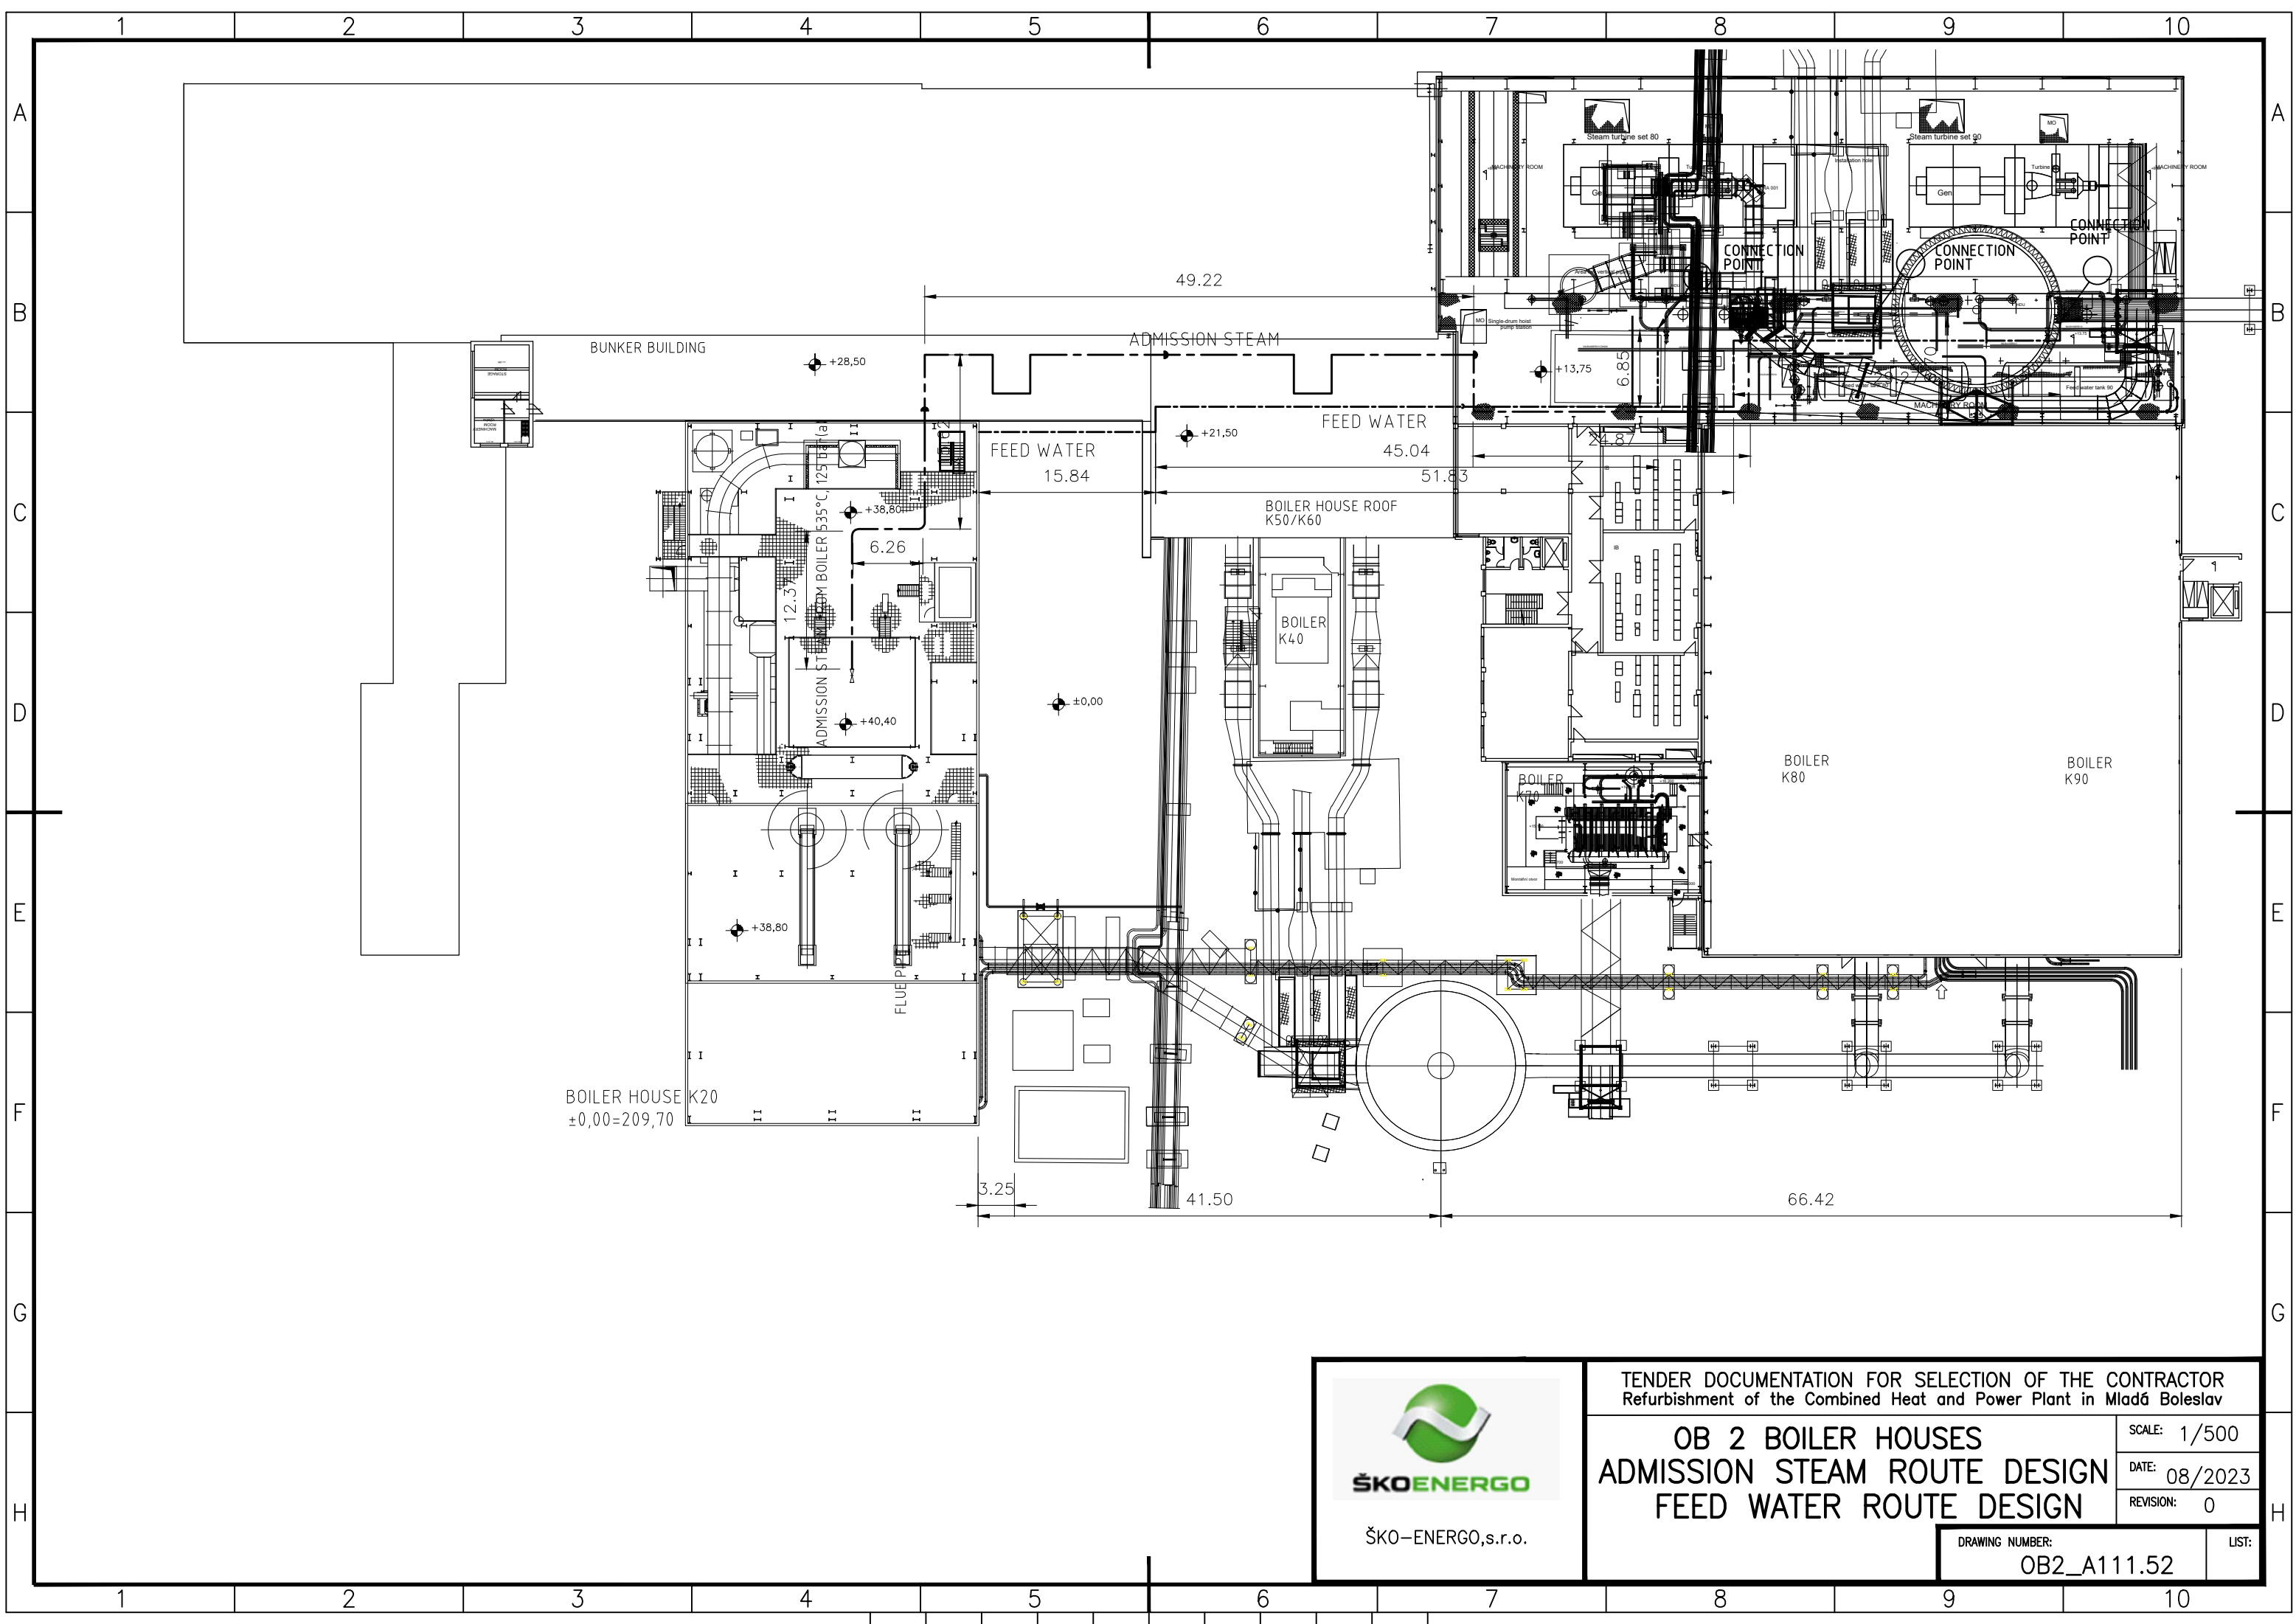

ŠKO-ENERGO,s.r.o.

TENDER DOCUMENTATION FOR SELECTION OF THE CONTRACTOR
Refurbishment of the Combined Heat and Power Plant in Mladá Boleslav

OB 2 BOILER HOUSES
ADMISSION STEAM ROUTE DESIGN
FEED WATER ROUTE DESIGN

SCALE: 1/500
DATE: 08/2023
REVISION: 0

DRAWING NUMBER:
OB2_A111.52

LIST: