


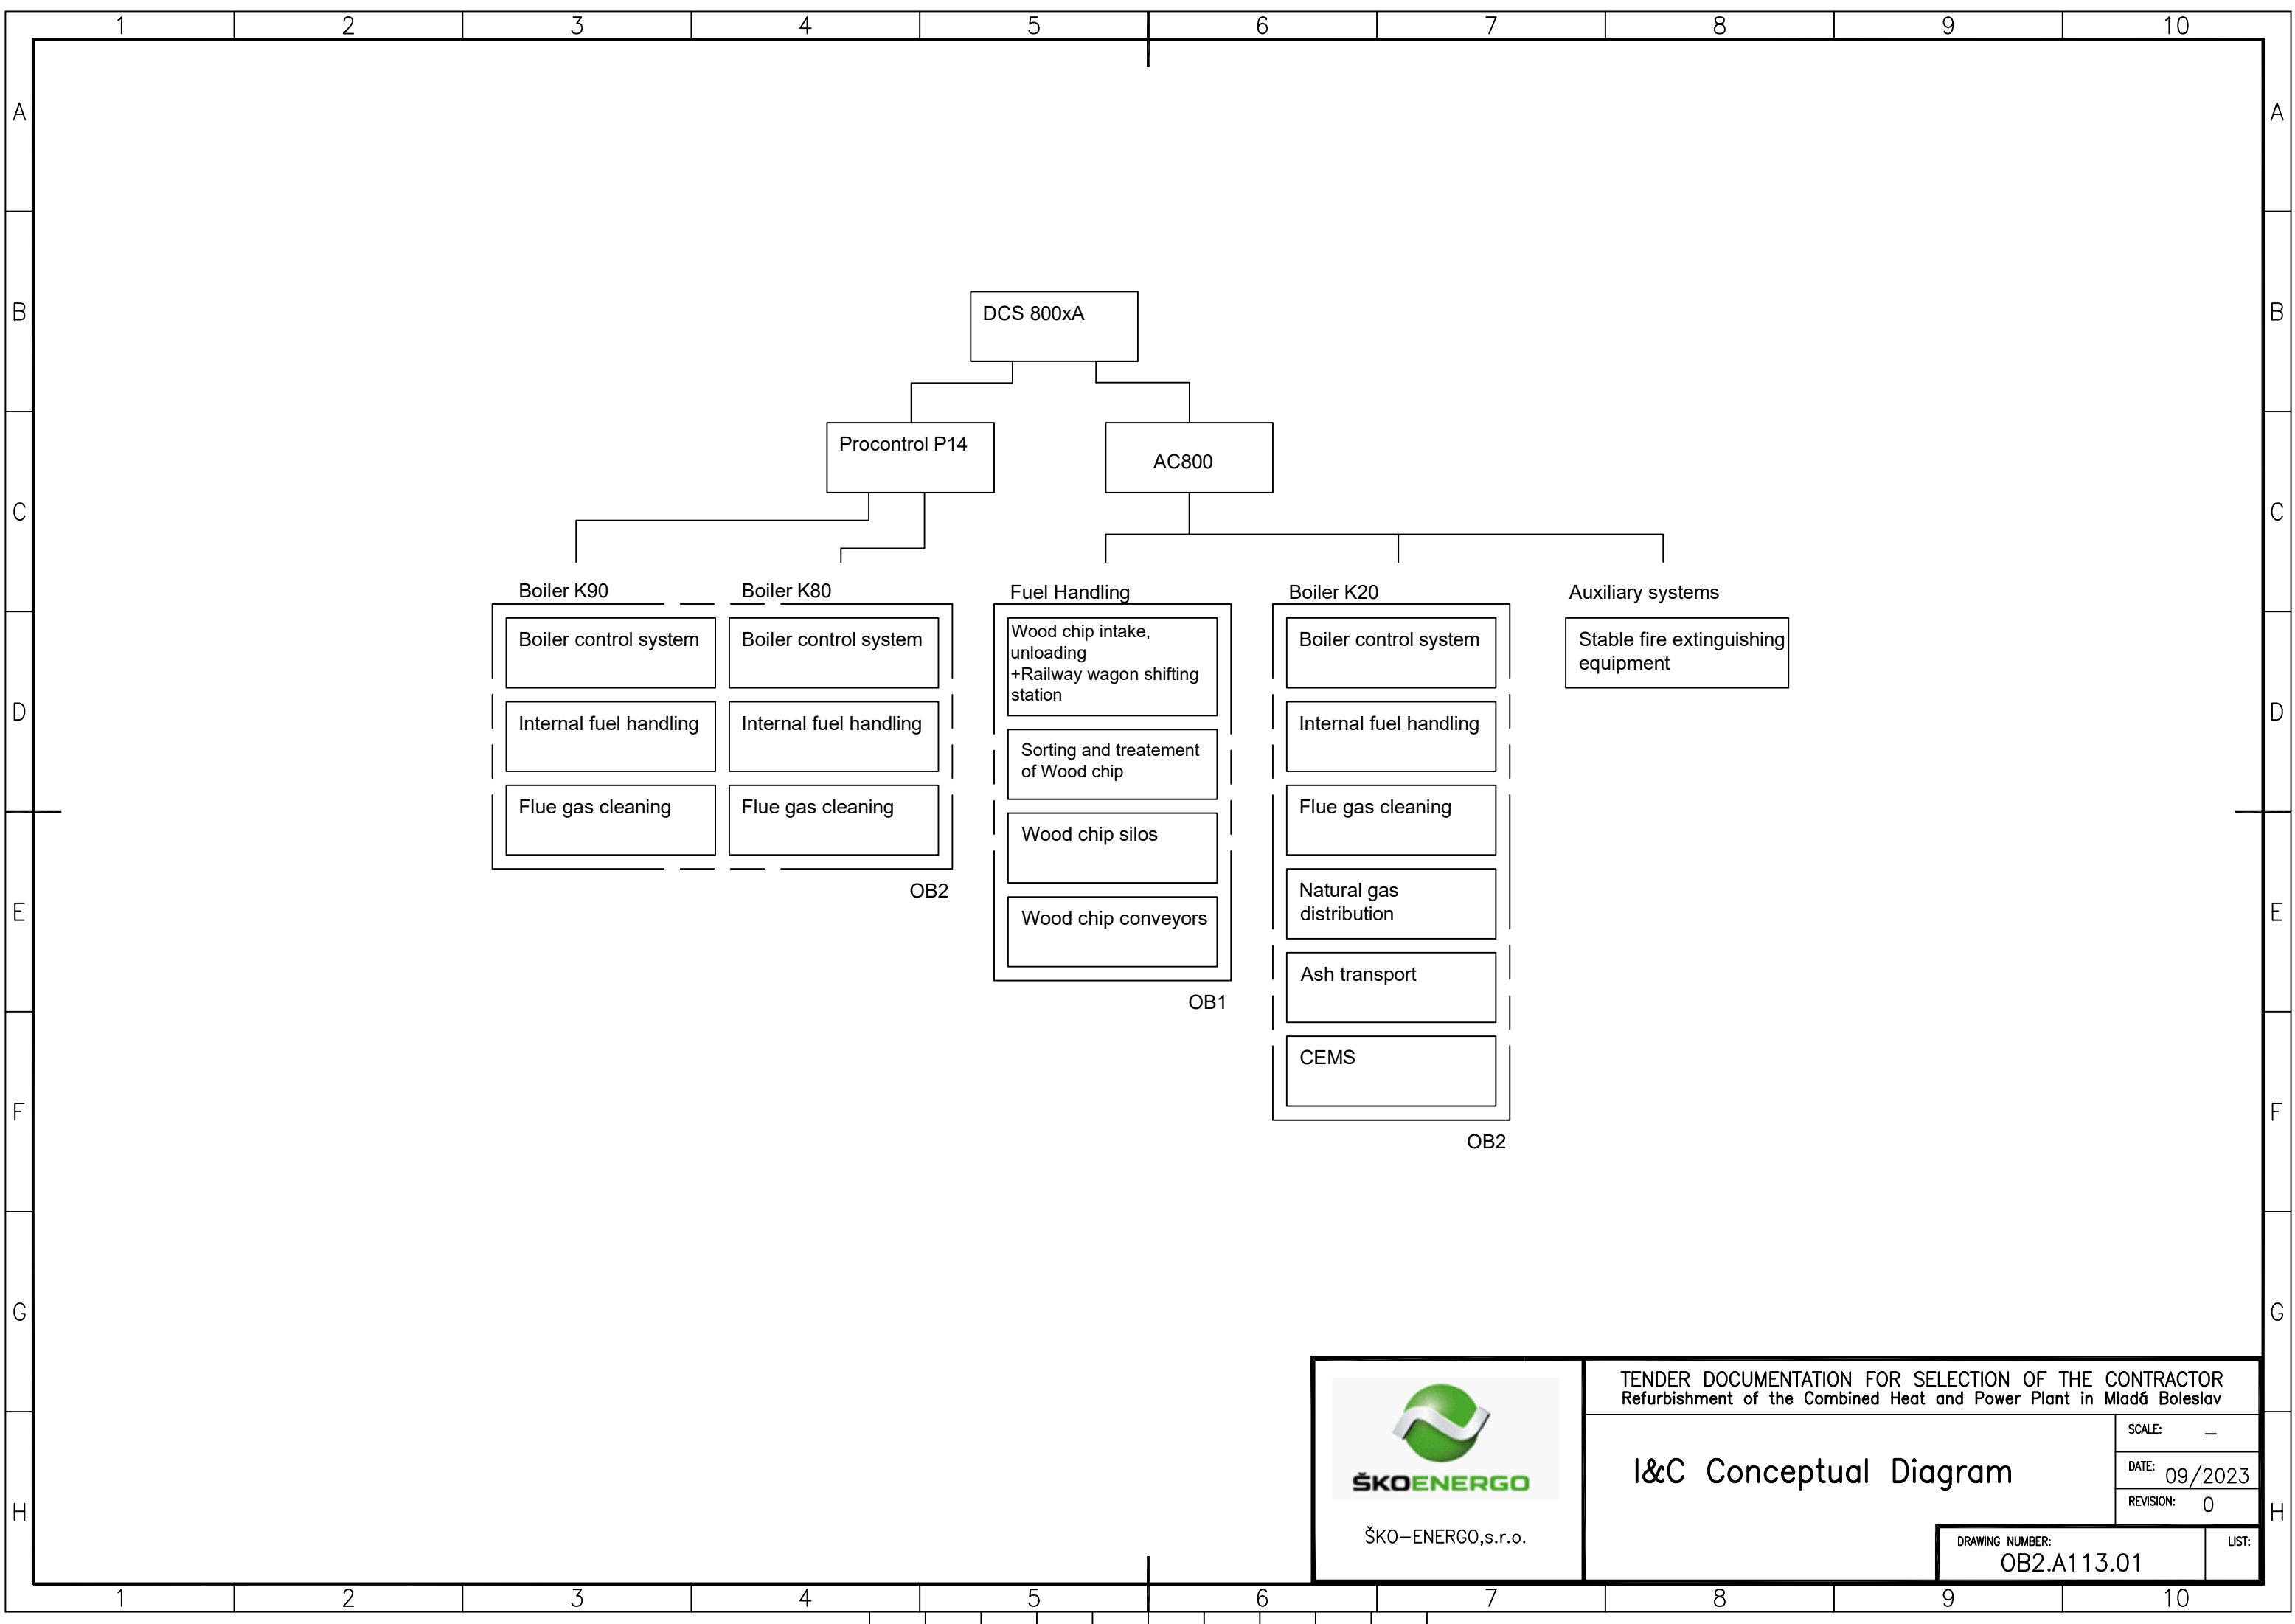

ŠKO-ENERGO,s.r.o.

TENDER DOCUMENTATION FOR SELECTION OF THE CONTRACTOR
Refurbishment of the Combined Heat and Power Plant in Mladá Boleslav

I&C Conceptual Diagram

SCALE: —
DATE: 09/2023
REVISION: 0

DRAWING NUMBER:
OB2.A113.01

LIST: