


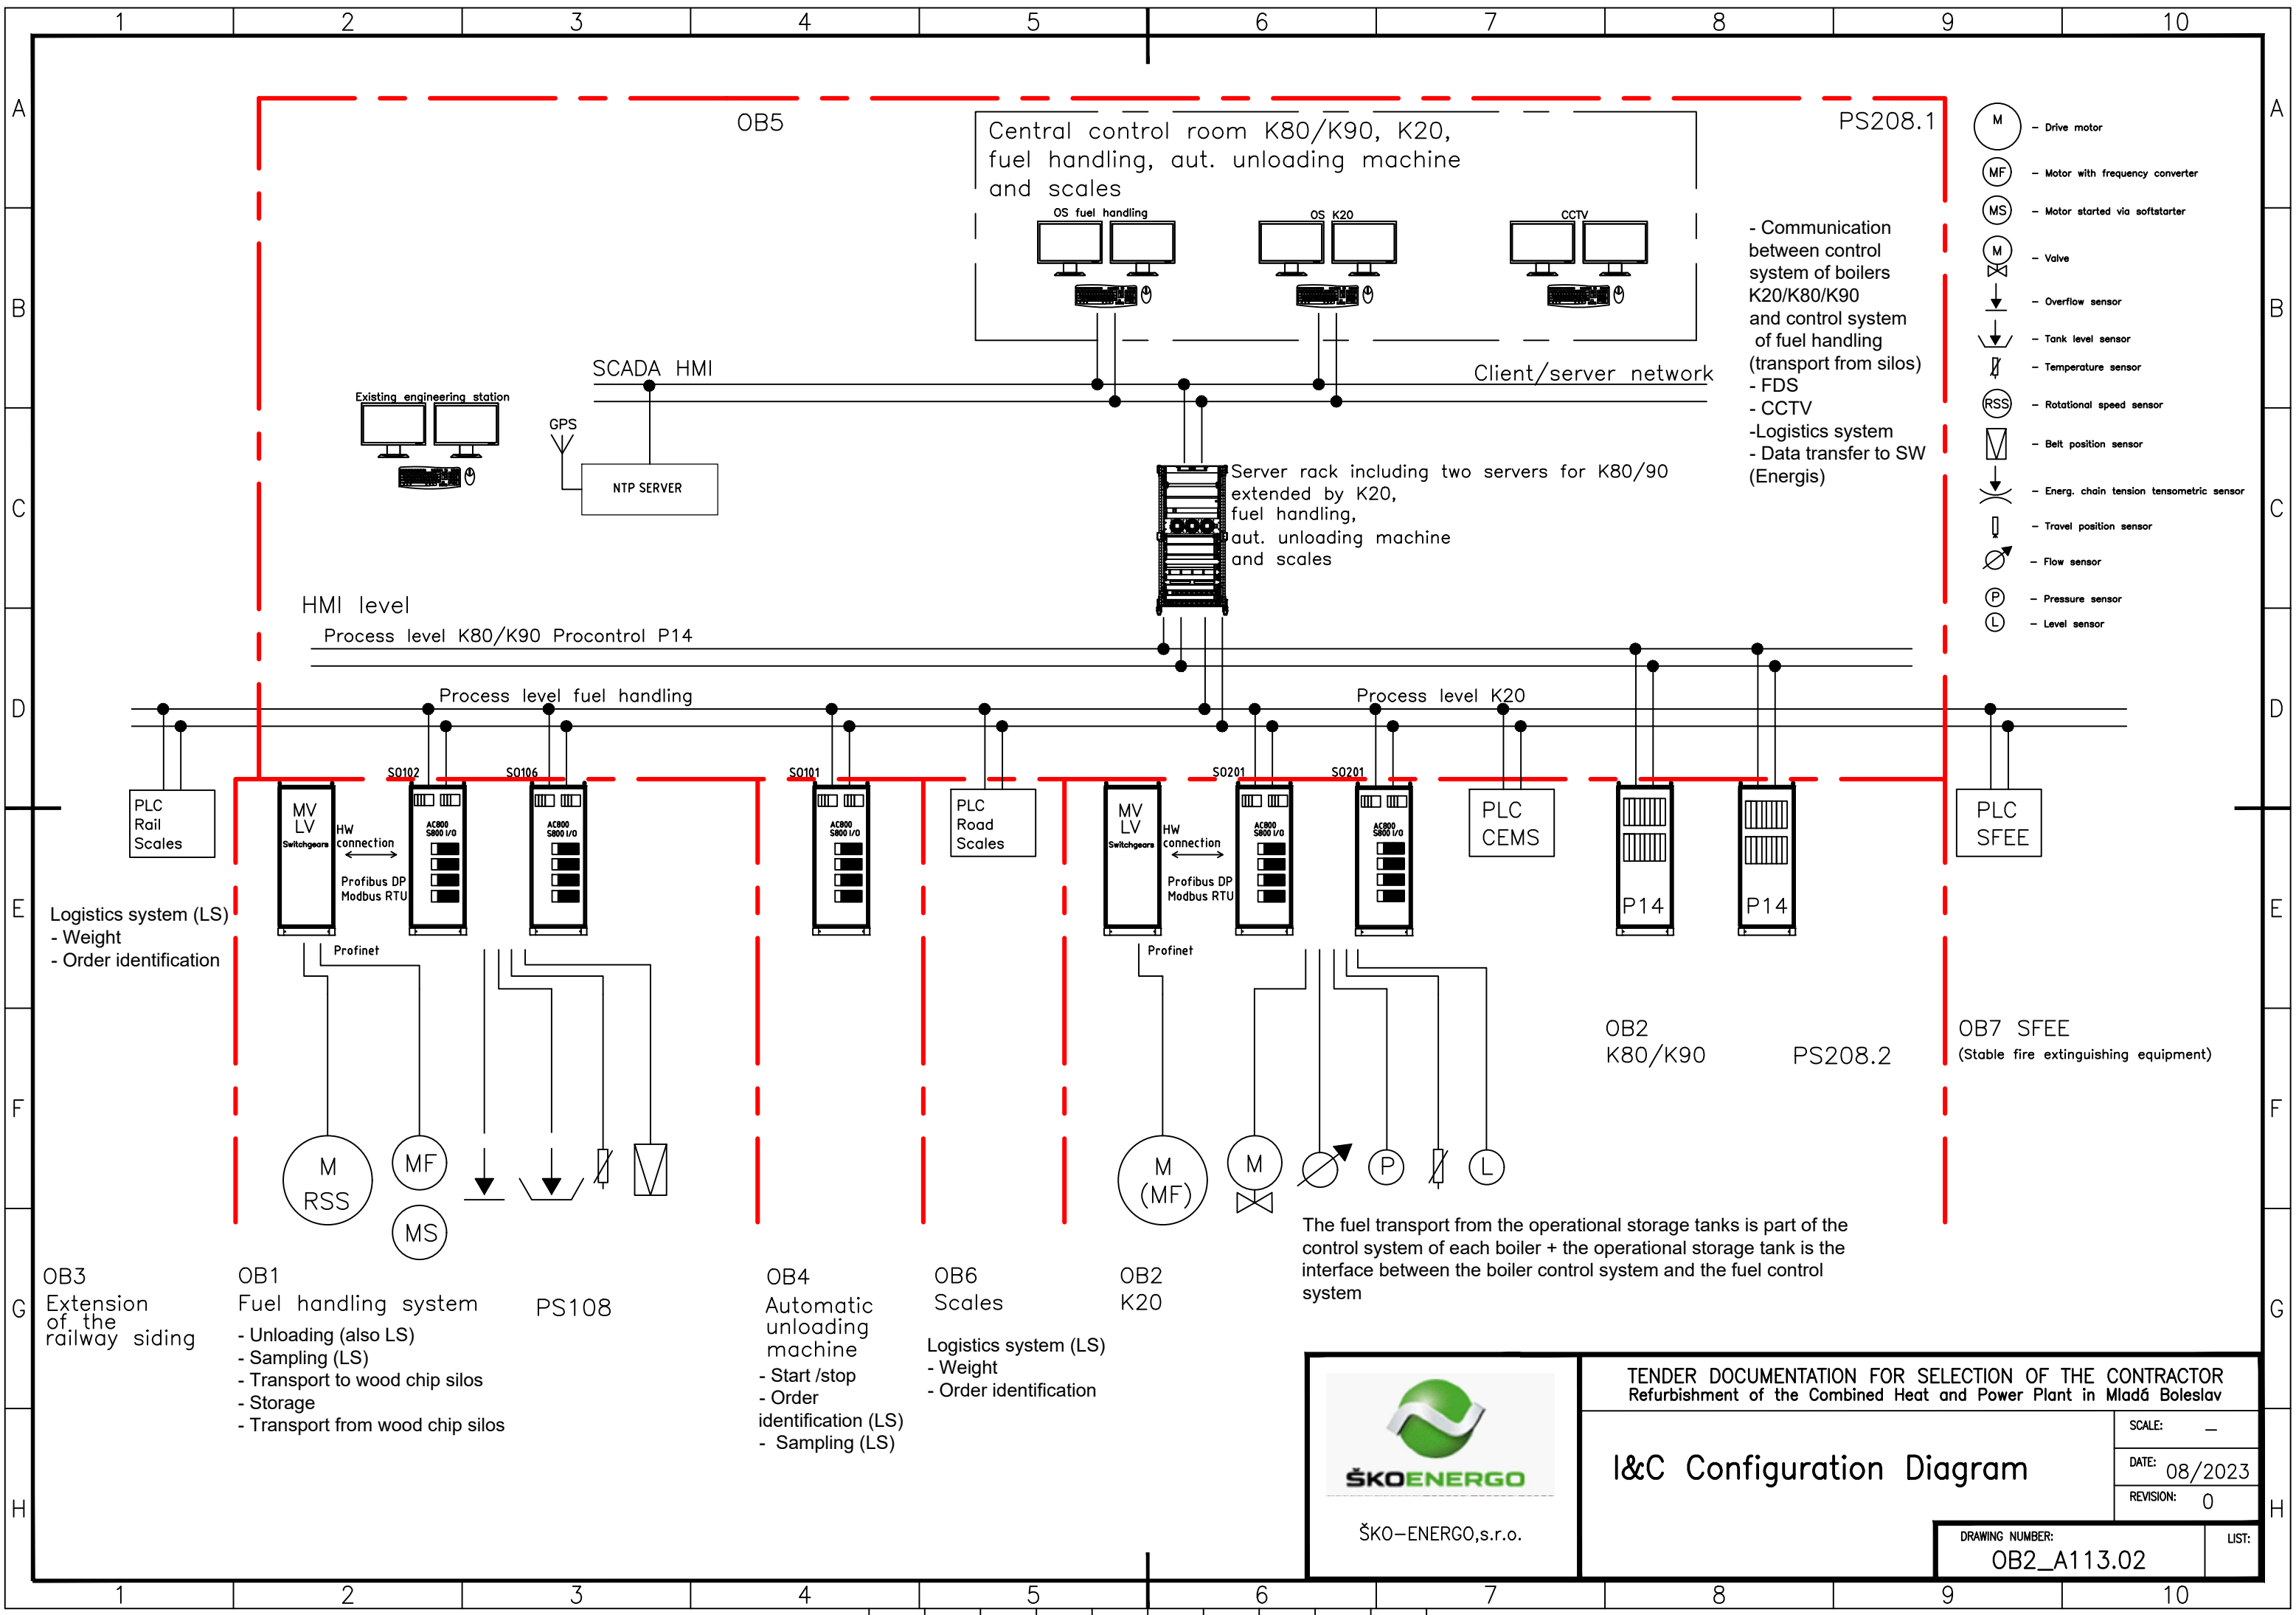

ŠKO-ENERGO, s.r.o.

TENDER DOCUMENTATION FOR SELECTION OF THE CONTRACTOR
Refurbishment of the Combined Heat and Power Plant in Mladá Boleslav

I&C Configuration Diagram

SCALE: —

DATE: 08/2023

REVISION: 0

DRAWING NUMBER:
OB2_A113.02

LIST: