


Boiler K20 ABB Control System

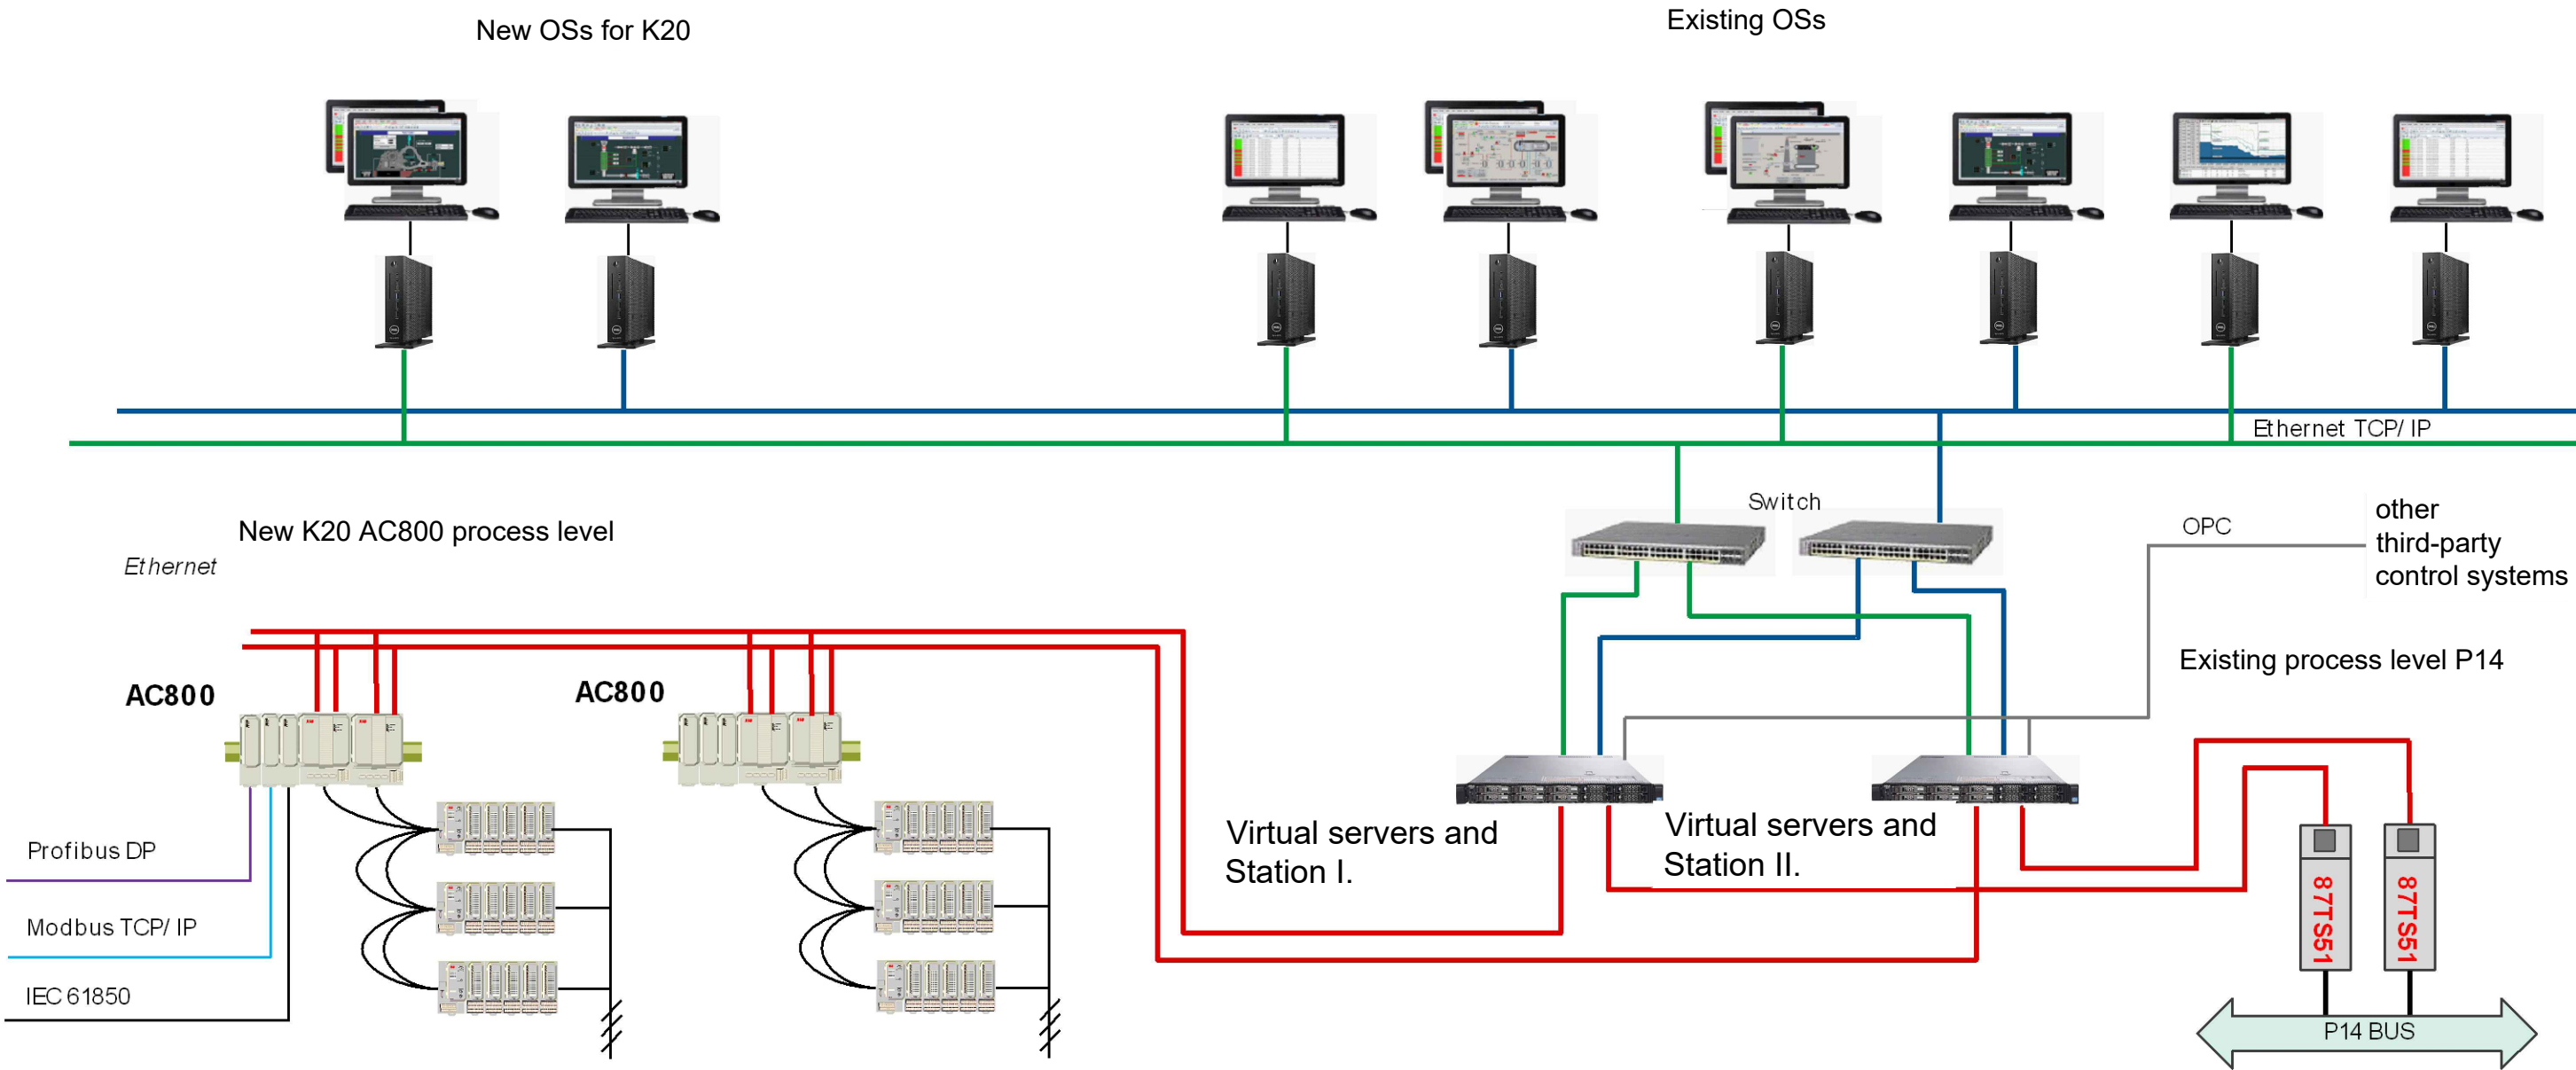

TENDER DOCUMENTATION FOR SELECTION OF THE CONTRACTOR Refurbishment of the Combined Heat and Power Plant in Mladá Boleslav	
Boiler K20 Control system diagram	SCALE: —
	DATE: 08/2023
	REVISION: 0
DRAWING NUMBER: OB2.A113.03	
LIST:	