


FLOOR +11,20m

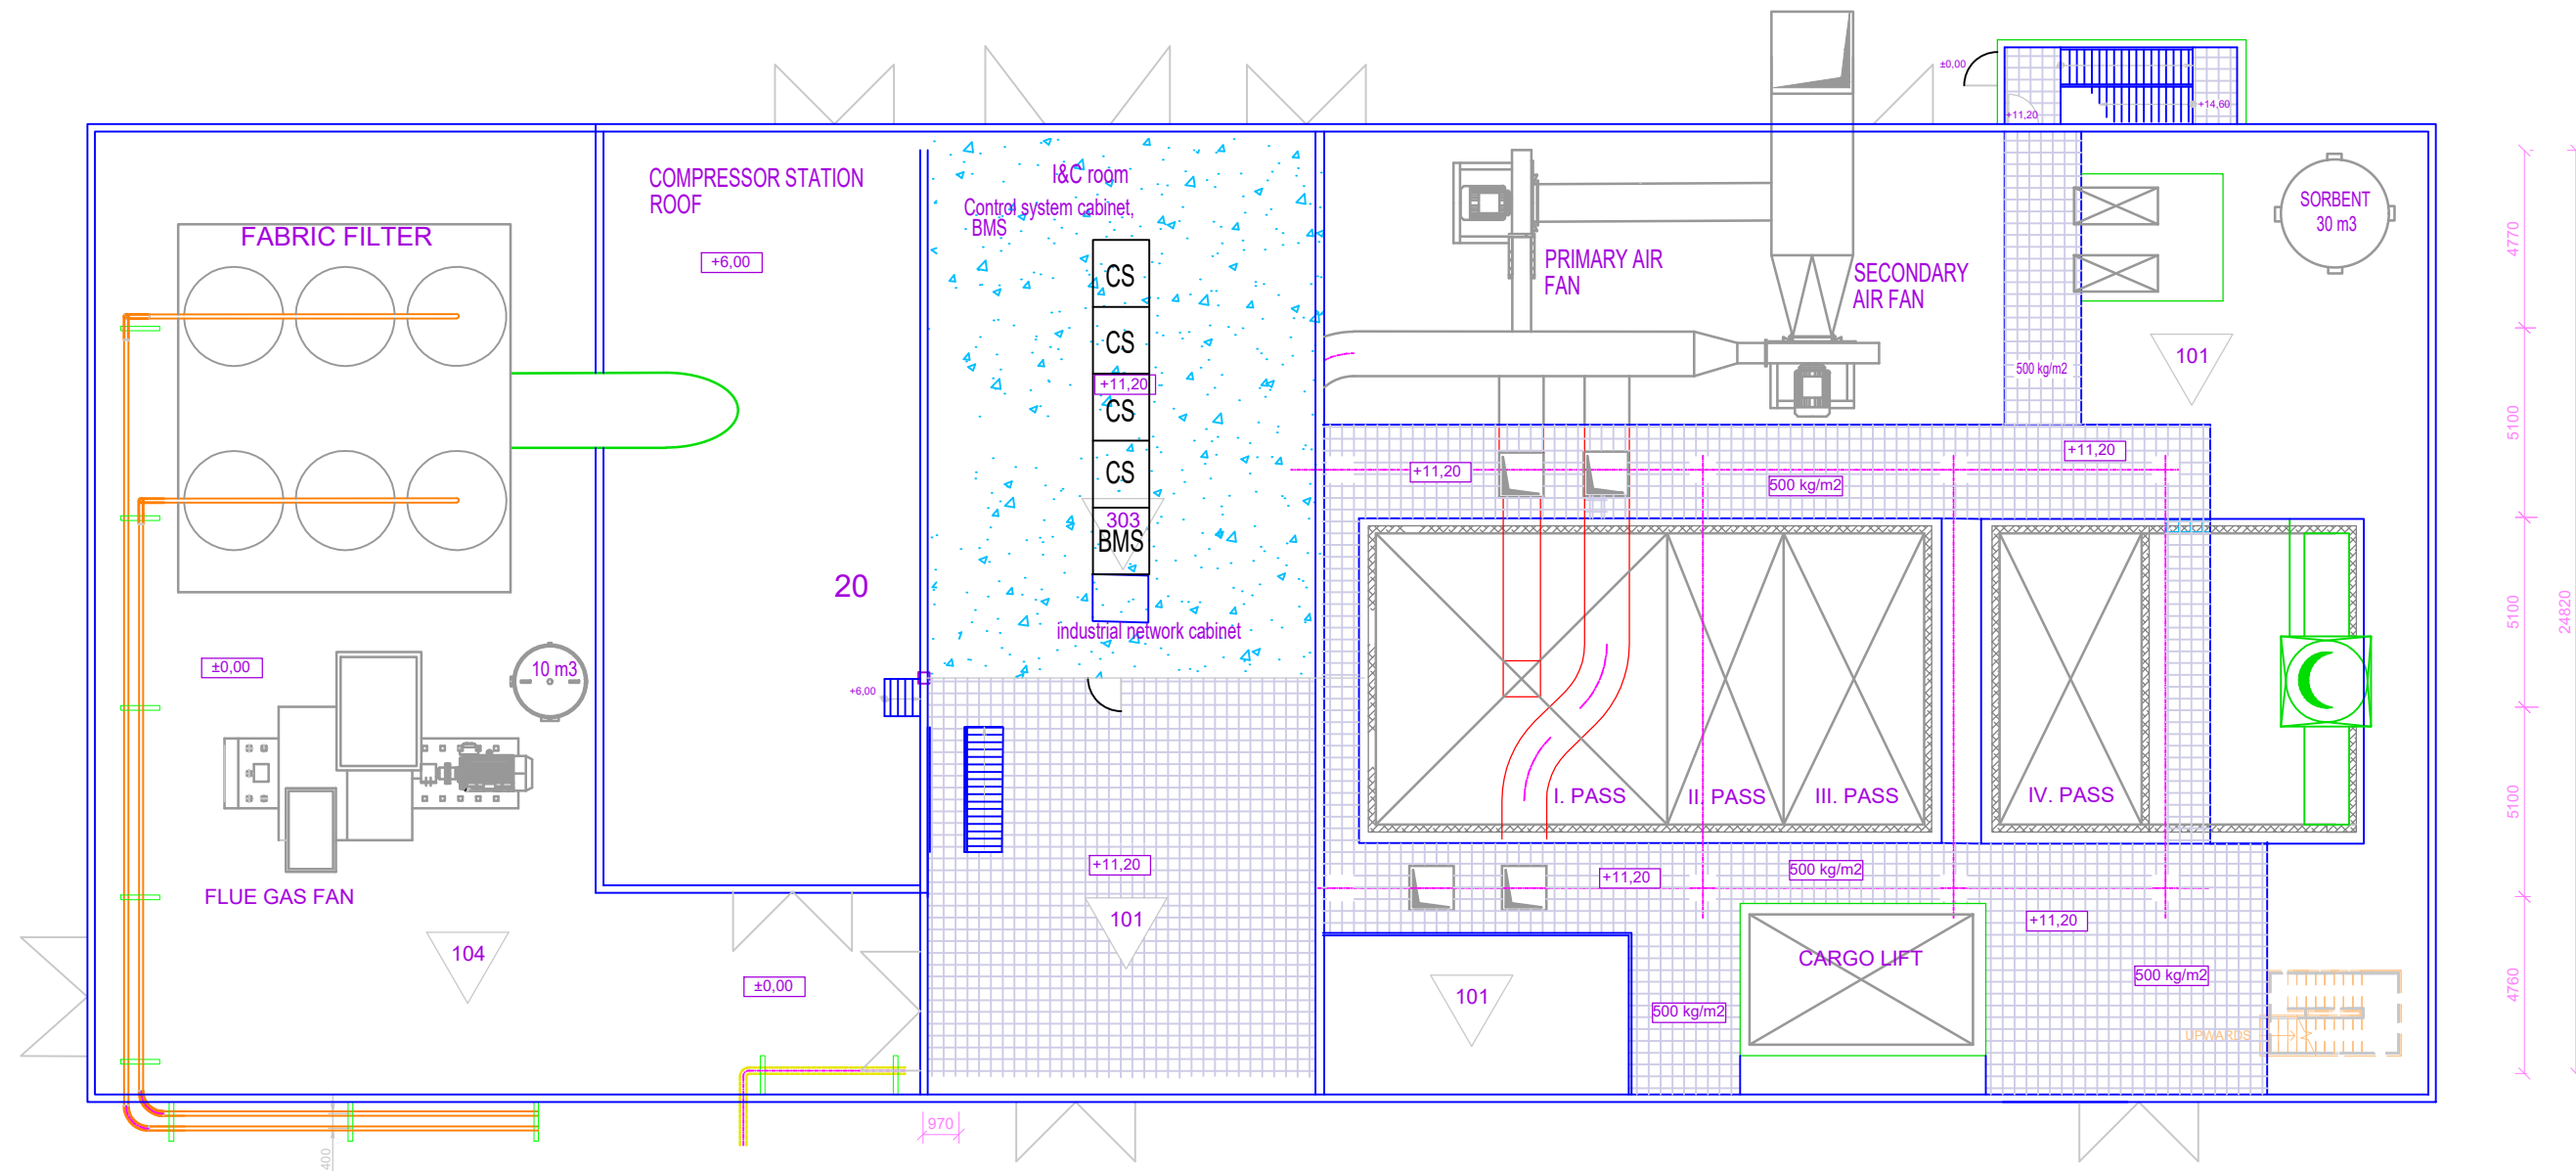

4770
5100
5100
5100
4760
24820



ŠKO-ENERGO, s.r.o.

TENDER DOCUMENTATION FOR SELECTION OF THE CONTRACTOR
Refurbishment of the Combined Heat and Power Plant in Mladá Boleslav

Disposition of room I&C +11,20

SCALE: —
DATE: 08/2023
REVISION: 0

DRAWING NUMBER:
OB2_A113.04